

CONSULTANT TEAM

PROJECT CONSULTANT: TERRA CONSULTING GROUP, LTD.
600 BUSSE HIGHWAY
PARK RIDGE, IL 60068
(847) 698-6400

VICINITY MAP

REGIONAL MAP

PROJECT TYPE

PROPOSED VERIZON P2P MICROWAVE INSTALLATION AT EXISTING VERIZON EQUIPMENT SHELTER.

PROJECT INFORMATION

SITE COORDINATES: LATITUDE: 42° 59' 20.16" N
LONGITUDE: 87° 59' 04.73" W

ADDRESS: 5600 W. OKLAHOMA
MILWAUKEE, WI 53219

CONSTRUCTION TYPE: P2P MICROWAVE INSTALLATION

APPLICANT: VERIZON WIRELESS
1701 GOLF ROAD, TOWER 2, SUITE 400
ROLLING MEADOWS, IL 60008

TOWER OWNER: CITY OF MILWAUKEE
809 N BROADWAY
MILWAUKEE, WI 53202

verizon

1701 GOLF ROAD, TOWER 2, SUITE 400
ROLLING MEADOWS, ILLINOIS 60008
PHONE: (847) 619-5397 FAX: (847) 706-7415

LOCATION NUMBER: 113511

SITE NAME: MFD 56TH AND OKLAHOMA RELO - A

5600 W. OKLAHOMA
MILWAUKEE, WI 53219

SHEET

DRAWING INDEX

REVISION

T-1

TITLE SHEET

-

C-1

SITE PLAN

-

C-2

SHELTER ROOF PLAN

-

C-3

SITE DETAILS

-

WISCONSIN

JOHN J. ZIMMERMAN

52948

PARK RIDGE, IL

PROFESSIONAL ENGINEER

3/31/2023

22" x 34" IS FULL SCALE.
11" x 17" IS HALF SCALE.

verizon

1701 GOLF ROAD,
TOWER 2, SUITE 400
ROLLING MEADOWS, IL 60008
PHONE: (847) 619-5397
FAX: (847) 706-7415

TERRA

CONSULTING GROUP, LTD.
600 BUSSE HIGHWAY
PARK RIDGE, IL 60068
PH: 847-698-6400
FAX: 847-698-6401

REVISIONS

NO.	DATE	BY	DESCRIPTION
1	12/06/22	XSJ	ISSUED FOR REVIEW
0	03/31/23	XSJ	ISSUED FOR FINALS

LOC. # 113511

MFD 56TH AND OKLAHOMA
RELO - A

5600 W. OKLAHOMA
MILWAUKEE, WI 53219

DRAWN BY: XSJ

CHECKED BY: TAZ

DATE: 12/06/22



PROJECT #: 223-112

SHEET TITLE

TITLE SHEET

SHEET NUMBER

T-1

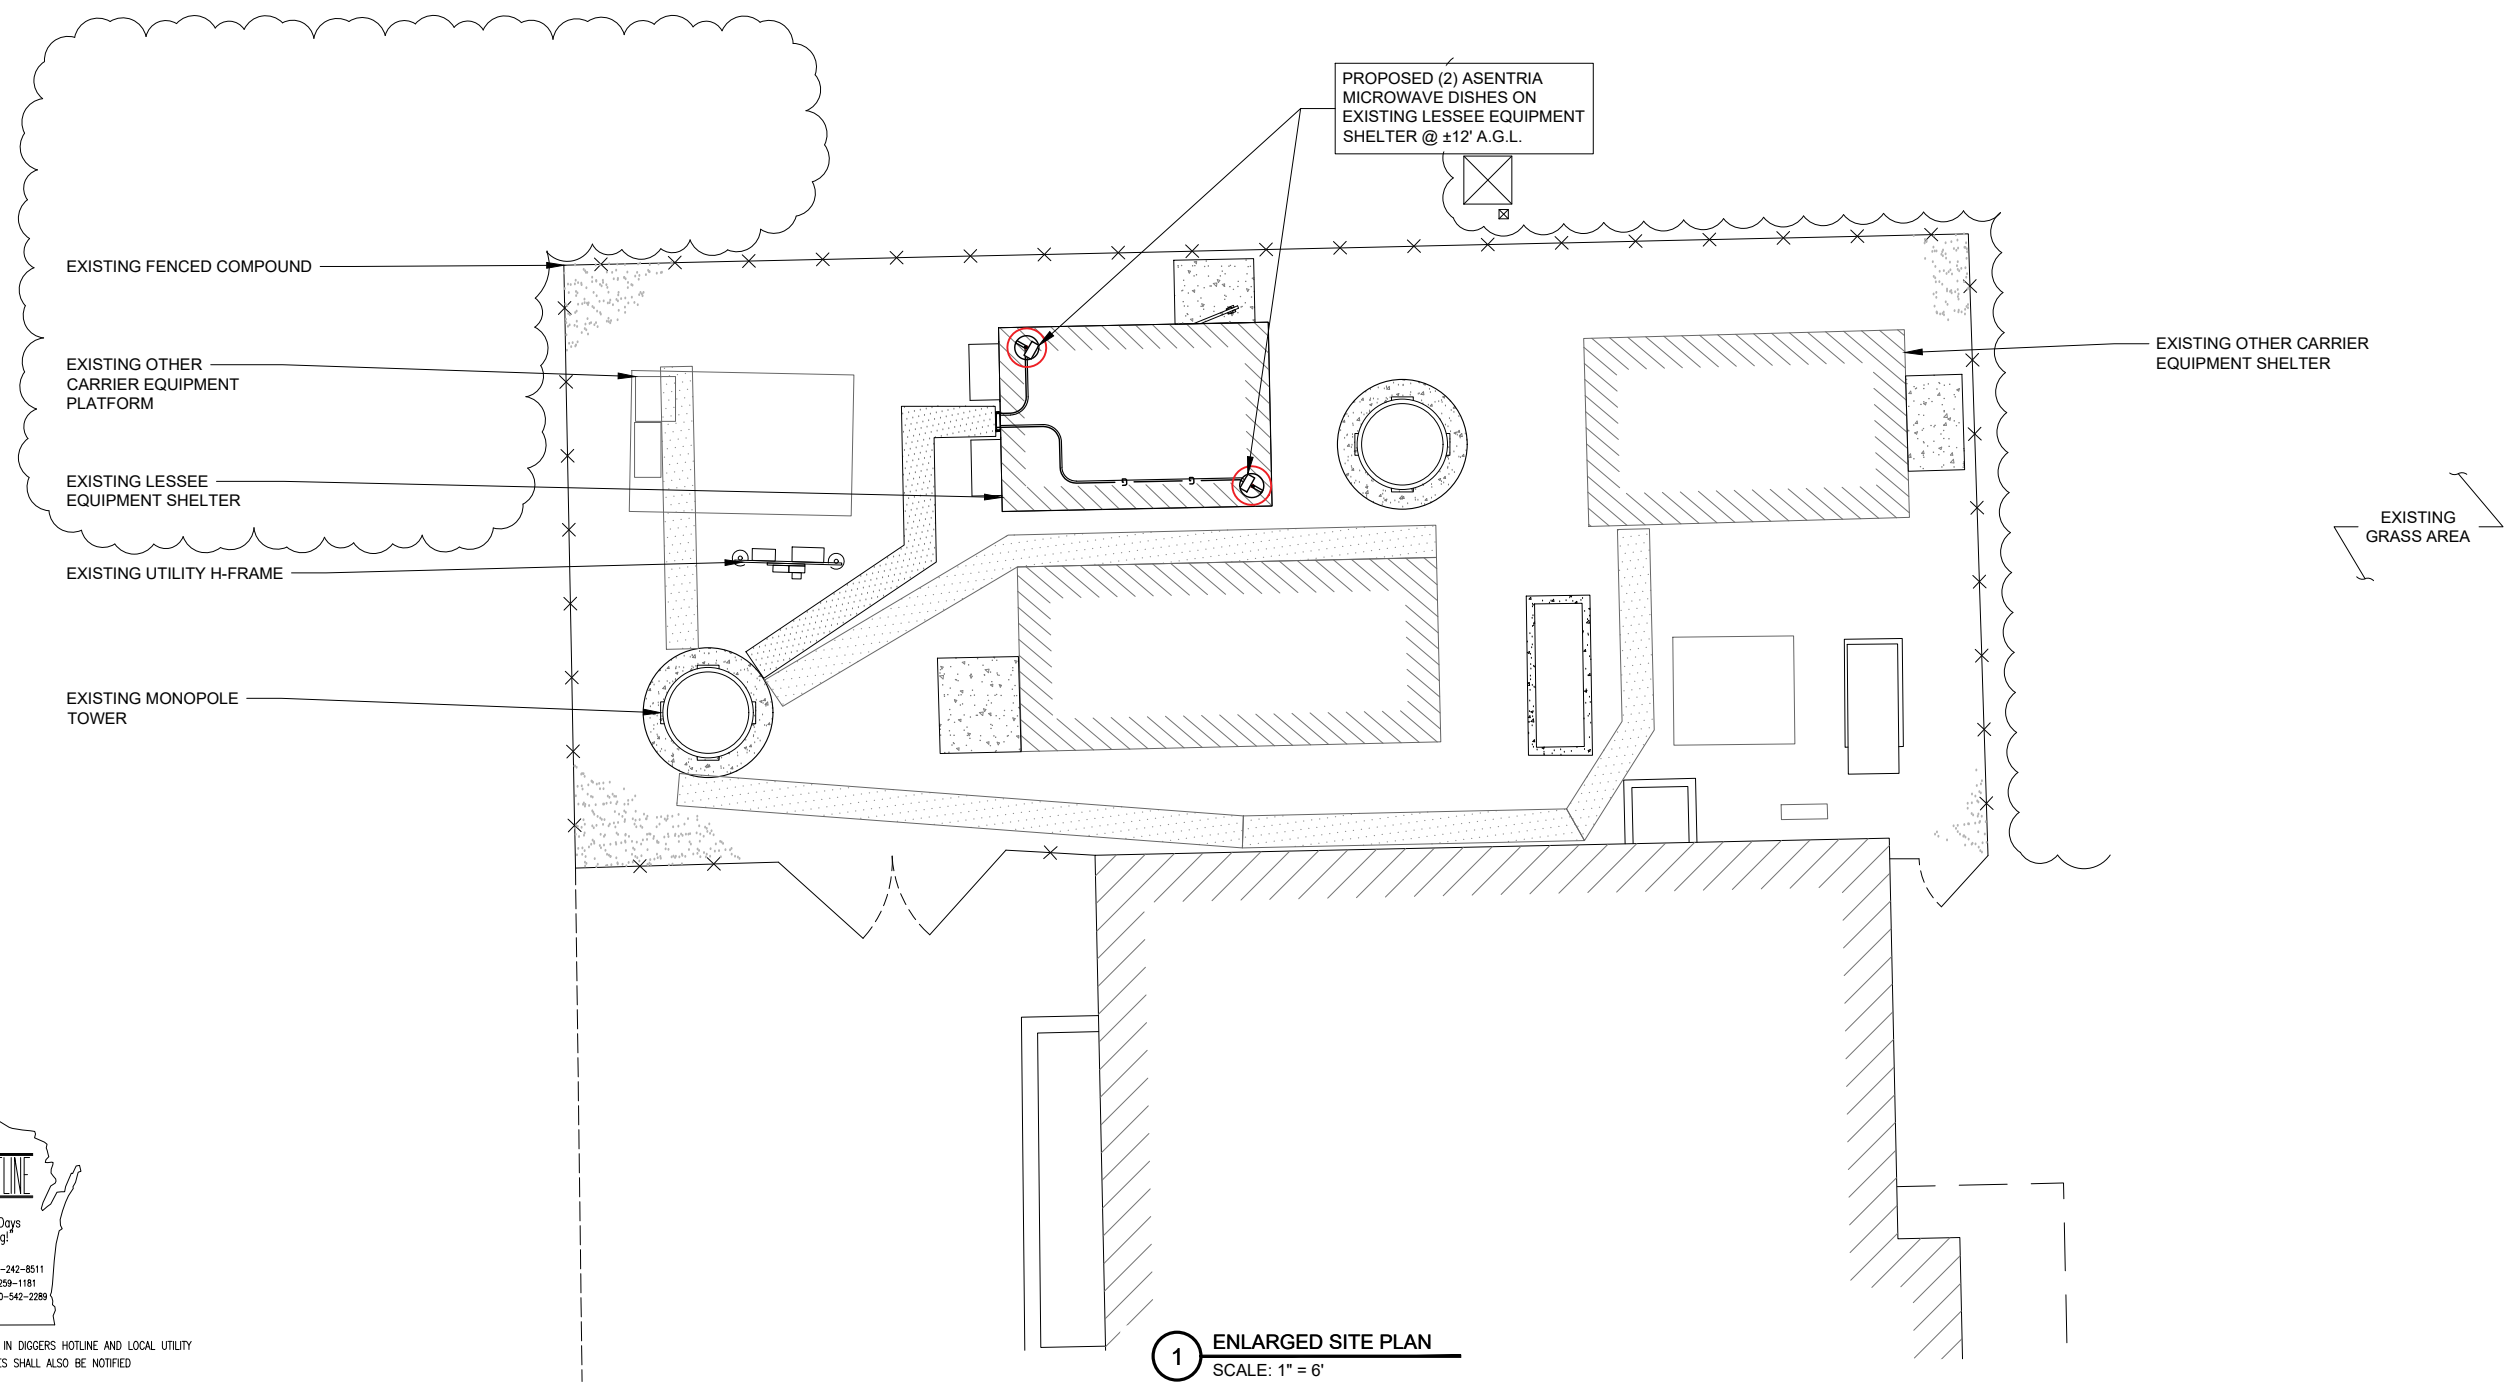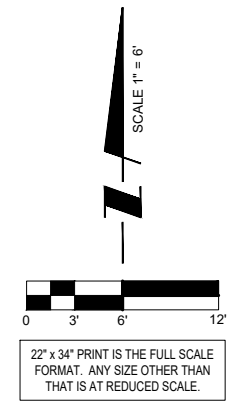

1 ENLARGED SITE PLAN
SCALE: 1" = 6'



OTHER UTILITIES NOT INCLUDED IN DIGGERS HOTLINE AND LOCAL UTILITY DISTRICTS AND COMPANIES SHALL ALSO BE NOTIFIED

verizon
1701 GOLF ROAD,
TOWER 2, SUITE 400
ROLLING MEADOWS, IL 60008
PHONE: (847) 619-5397
FAX: (847) 706-7415





REVISIONS			NO.	DESCRIPTION	DATE	BY
		ISSUED FOR REVIEW	1		12/08/22	XSJ
		ISSUED FOR FINALS	0		03/31/23	XSJ

LOC. # 113511
MFD 56TH AND OKLAHOMA RELO - A

5600 W. OKLAHOMA
MILWAUKEE, WI 53219


DRAWN BY:	XSJ
CHECKED BY:	TAZ
DATE:	12/06/22
PROJECT #:	223-112

SHEET TITLE
SITE PLAN
SHEET NUMBER
C-1

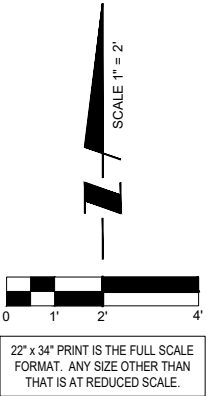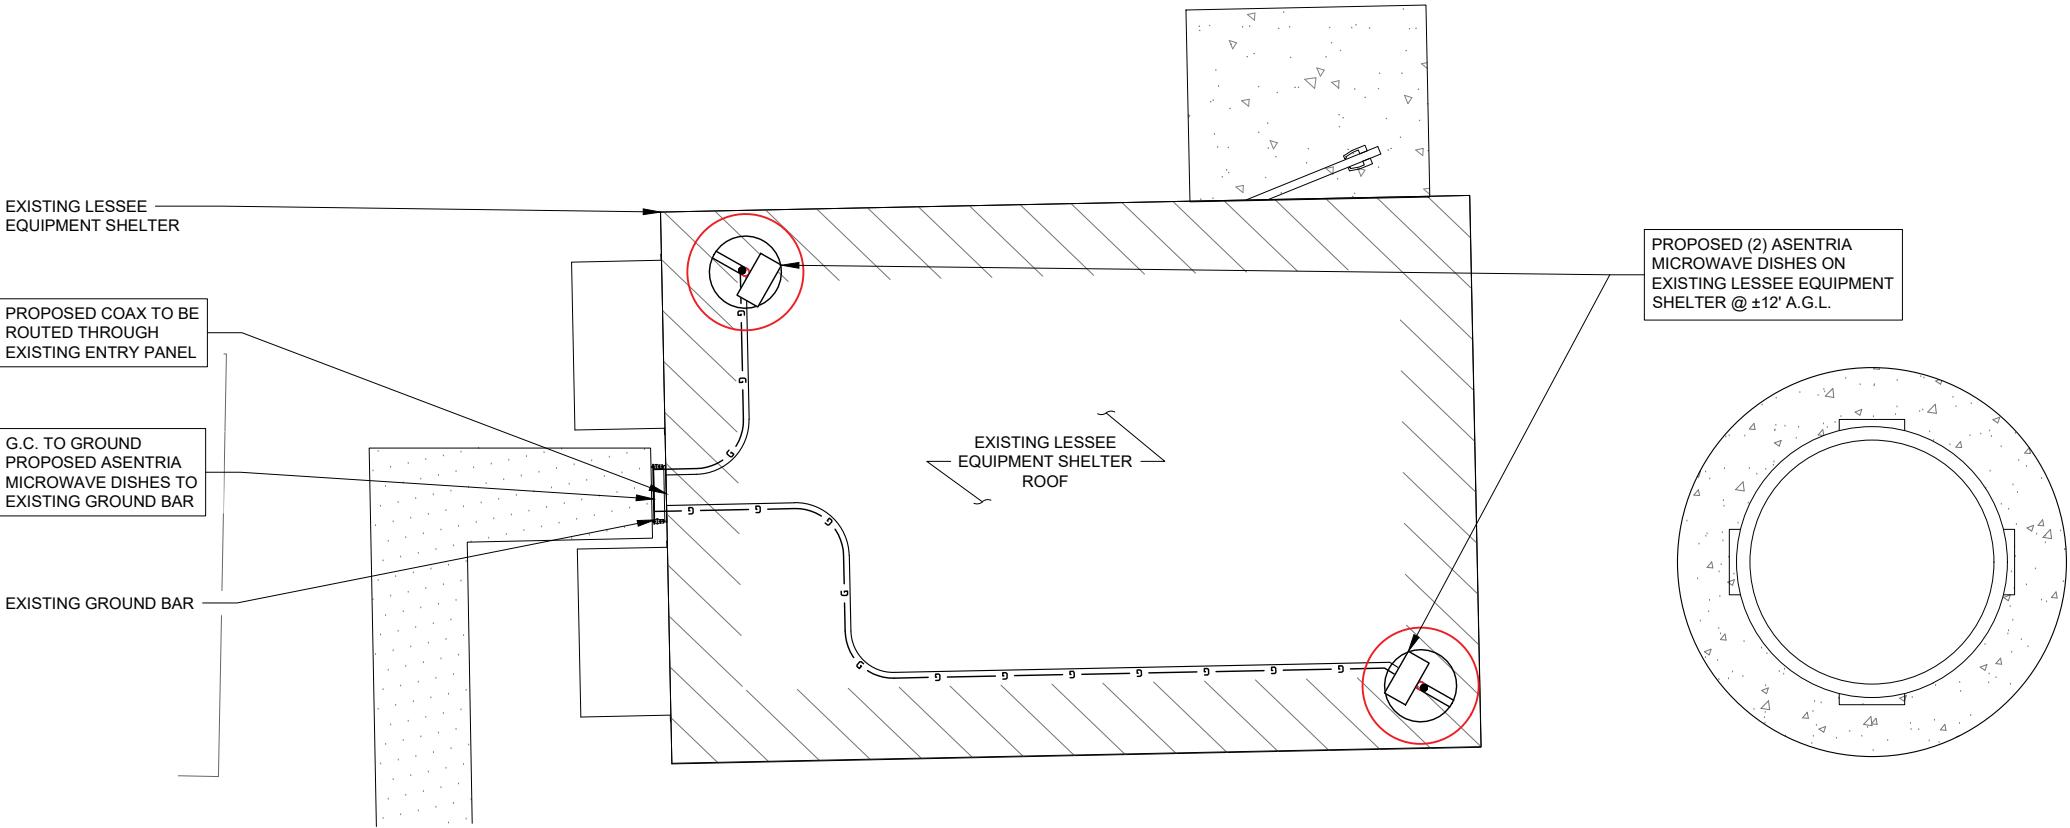

1 SHELTER PLAN
SCALE: 1" = 2'

NOTE TO G.C.:
G.C. TO USE MICROWAVE PROTECTIVE COVER AS NECESSARY

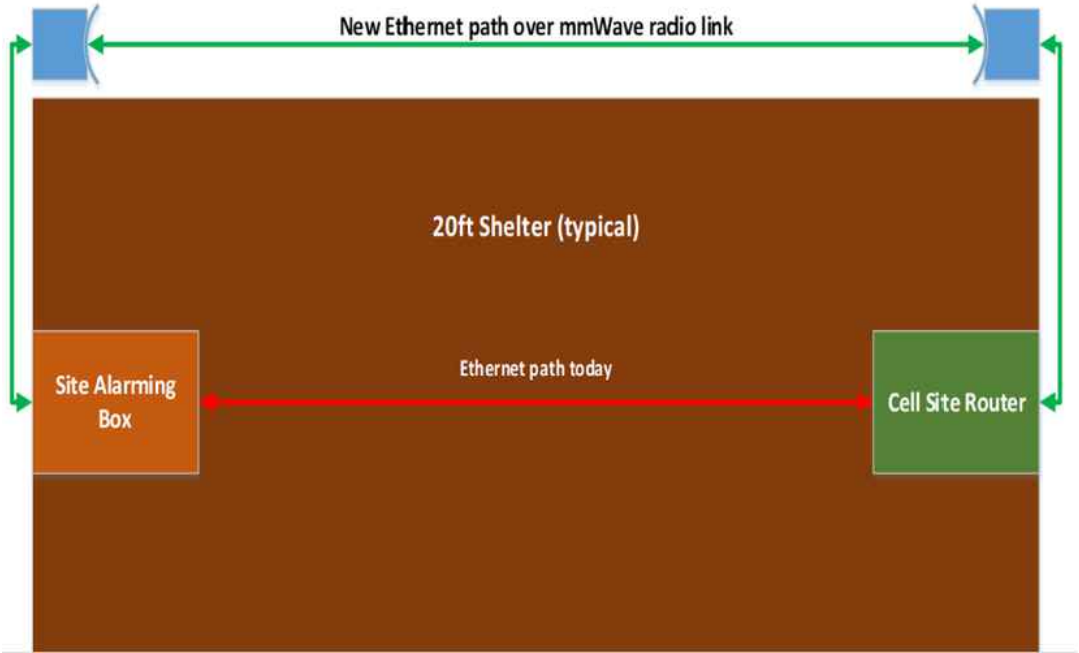

2 DESIGN PLAN
SCALE: 1" = 2'

verizon
1701 GOLF ROAD,
TOWER 2, SUITE 400
ROLLING MEADOWS, IL 60008
PHONE: (847) 619-5397
FAX: (847) 706-7415

TERRA
CONSULTING GROUP, LTD.
600 BUSSE HIGHWAY
PARK RIDGE, IL 60068
PH: 847-698-6400
FAX: 847-698-6401

REVISIONS							
NO.	DESCRIPTION	DATE	BY	NO.	DESCRIPTION	DATE	BY
1	ISSUED FOR REVIEW	12/08/22	XSJ	2	ISSUED FOR FINALS	03/31/23	XSJ

LOC. # 113511

MFD 56TH AND
OKLAHOMA
RELO - A

5600 W. OKLAHOMA
MILWAUKEE, WI 53219

DRAWN BY: XSJ

CHECKED BY: TAZ

DATE: 12/06/22

PROJECT #: 223-112

SHEET TITLE
SHELTER
ROOF PLAN

SHEET NUMBER

C-2




OTHER UTILITIES NOT INCLUDED IN DIGGERS HOTLINE AND LOCAL UTILITY
DISTRICTS AND COMPANIES SHALL ALSO BE NOTIFIED


PRODUCT:	LIGHT FREESTANDER
PRODUCT NUMBER:	NTK 301 1205/1
DIMENSIONS:	750MM (29,5") Ø60,3 MM (2,4") Ø600 MM (23,6")
MECHANICAL SPECIFICATIONS:	SHEET PROFILES, FASTENERS, STEEL AND 8.8 HDG OR EQUIVALENT
RECOMMENDED TOOLS:	M12 ISO, 18 MM BLOCK KEY AND TORQUE WRENCH (20-80 NM)




1 BALLAST SUPPORT STRUCTURE
SCALE: N.T.S.

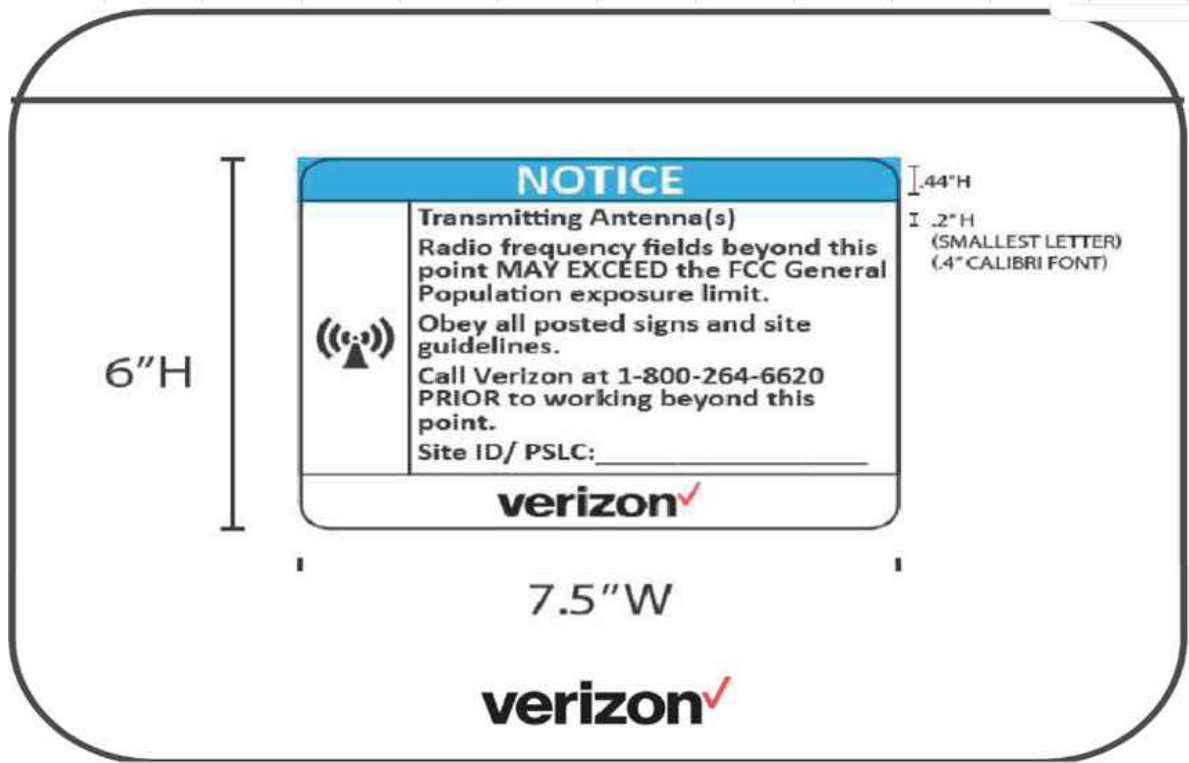


2 REQUIRED SIGNAGE
SCALE: N.T.S.

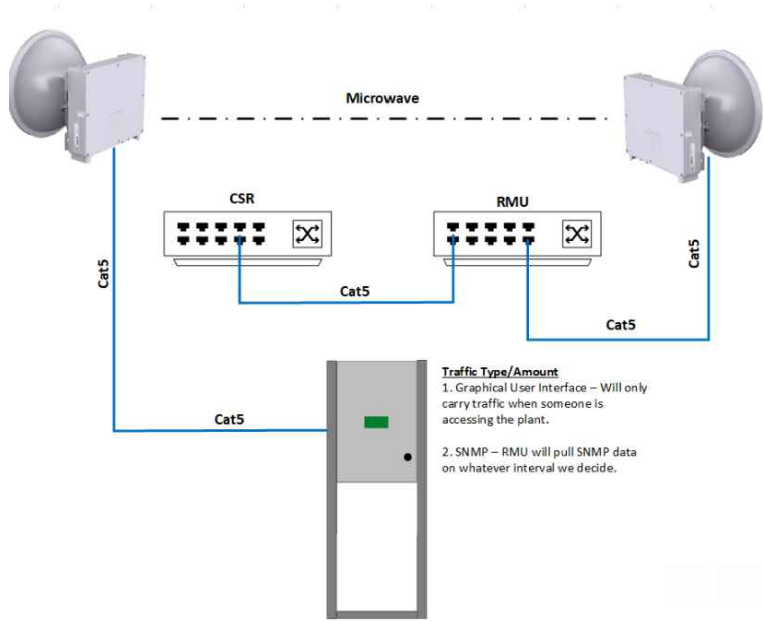

3 CHANGE IN LINK TRAFFIC PLAN
SCALE: N.T.S.

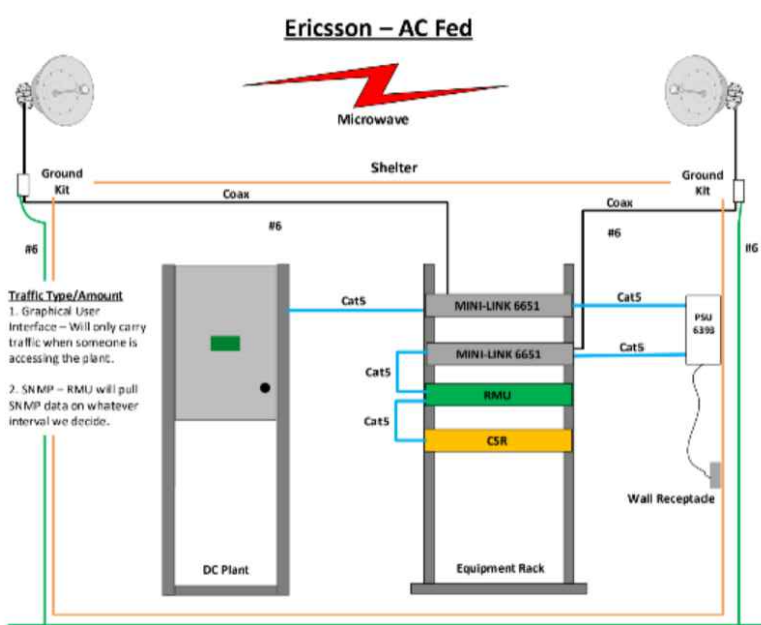

4 ERICCCSON-AC FED
SCALE: N.T.S.

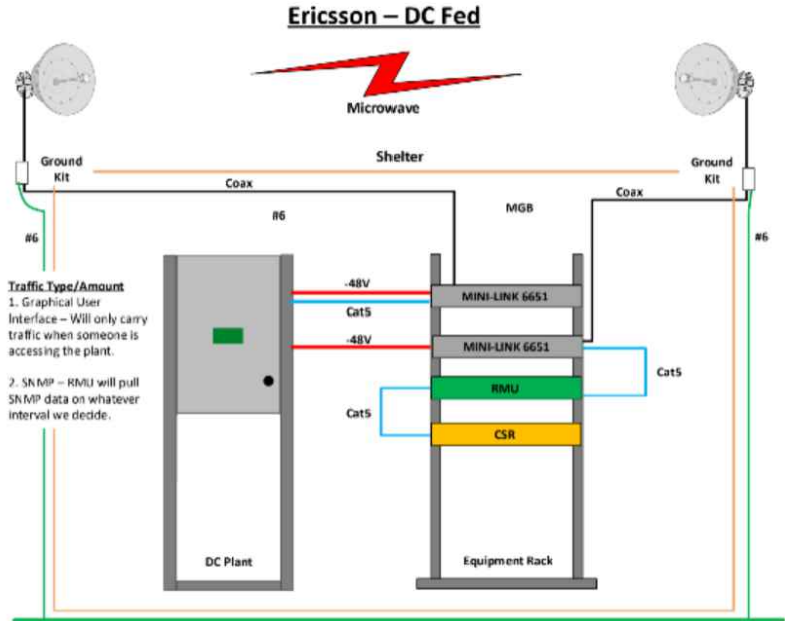

5 ERICCCSON-DC FED
SCALE: N.T.S.

verizon
1701 GOLF ROAD,
TOWER 2, SUITE 400
ROLLING MEADOWS, IL 60008
PHONE: (847) 619-5397
FAX: (847) 706-7415

TERRA
CONSULTING GROUP, LTD.
600 BUSSE HIGHWAY
PARK RIDGE, IL 60068
PH: 847-698-6400
FAX: 847-698-6401

REVISIONS		NO.	DESCRIPTION	DATE	BY
	ISSUED FOR REVIEW	1		12/06/22	XSJ
	ISSUED FOR FINALS	2		03/31/23	XSJ

LOC. # 113511

MFD 56TH AND
OKLAHOMA
RELO - A

5600 W. OKLAHOMA
MILWAUKEE, WI 53219

DRAWN BY:	XSJ
CHECKED BY:	TAZ
DATE:	12/06/22
PROJECT #:	223-112

SHEET TITLE
SITE DETAILS

SHEET NUMBER

C-3