


WEST SHORE PIPELINE COMPANY

124TH STREET RELOCATE - 16" PETROLEUM PIPELINE

ALIGNMENT DRAWINGS

AUGUST 2004


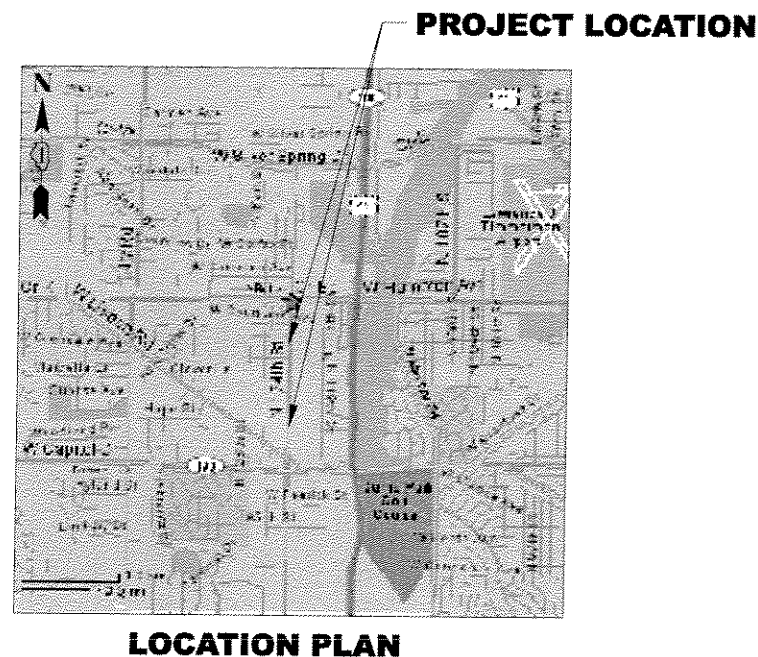


<u>SHEET</u> <u>No.</u>	<u>TITLE</u>	<u>DESCRIPTION</u>
1	COVER	SHEET INDEX AND LOCATION MAP
2	CP-1	PLAN AND PROFILE STA 24+00 TO STA 30+00
3	CP-2	PLAN AND PROFILE STA 30+00 TO STA 36+00
4	CP-3	PLAN AND PROFILE STA 36+00 TO STA 41+00
5	CP-4	PLAN AND PROFILE STA 41+00 TO STA 47+00
6	CP-5	PLAN AND PROFILE STA 47+00 TO END STA



GENERAL NOTES

- 1.) PIPE TO BE WELDED IN ACCORDANCE W/
- 2.) ALL BENDS SHALL BE 5D RADIUS HEAT INDUCED PIPE BENDS
PER OWNER SPECIFICATION
- 3.) PIPE SHALL BE INSTALLED WITH A MINIMUM 4 FEET COVER
- 4.) MAINTAIN A MINIMUM OF 12 INCHES CLEARANCE BETWEEN PIPE
AND FOREIGN LINE CROSSINGS
- 5.) ABANDONED PIPE SECTION TO BE LEFT IN PLACE AND FILLED W/GROUT

CAMP DRESSER & McKEE INC.
MILWAUKEE, WISCONSIN

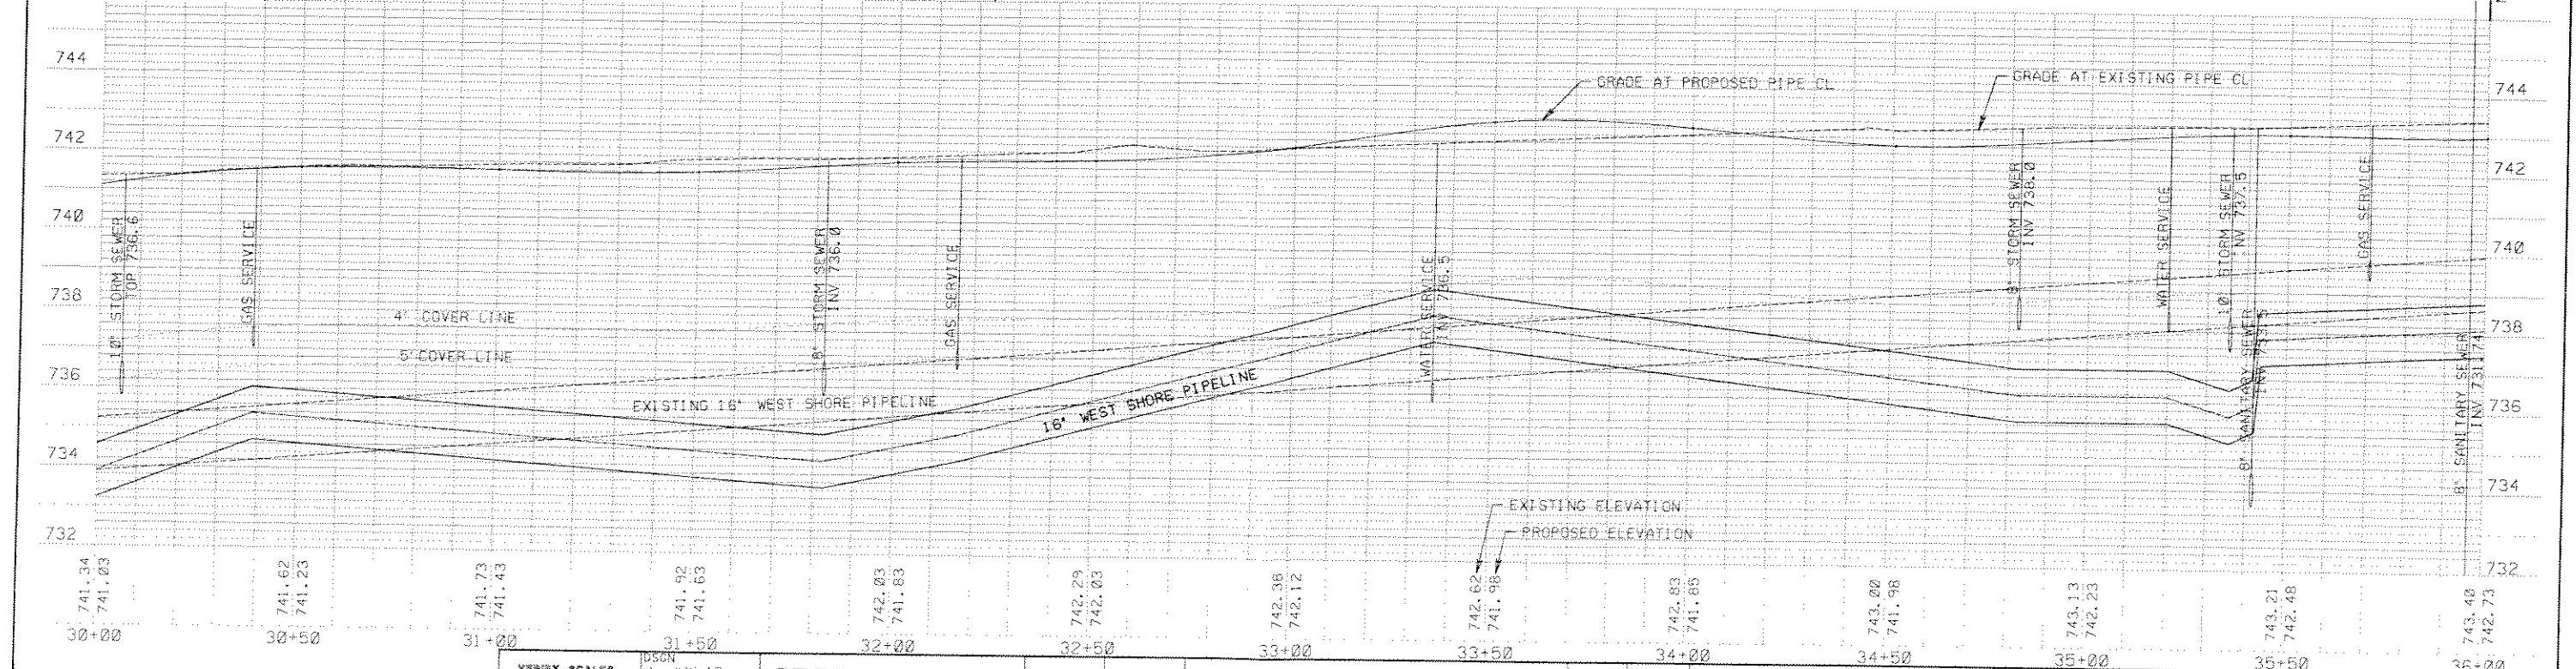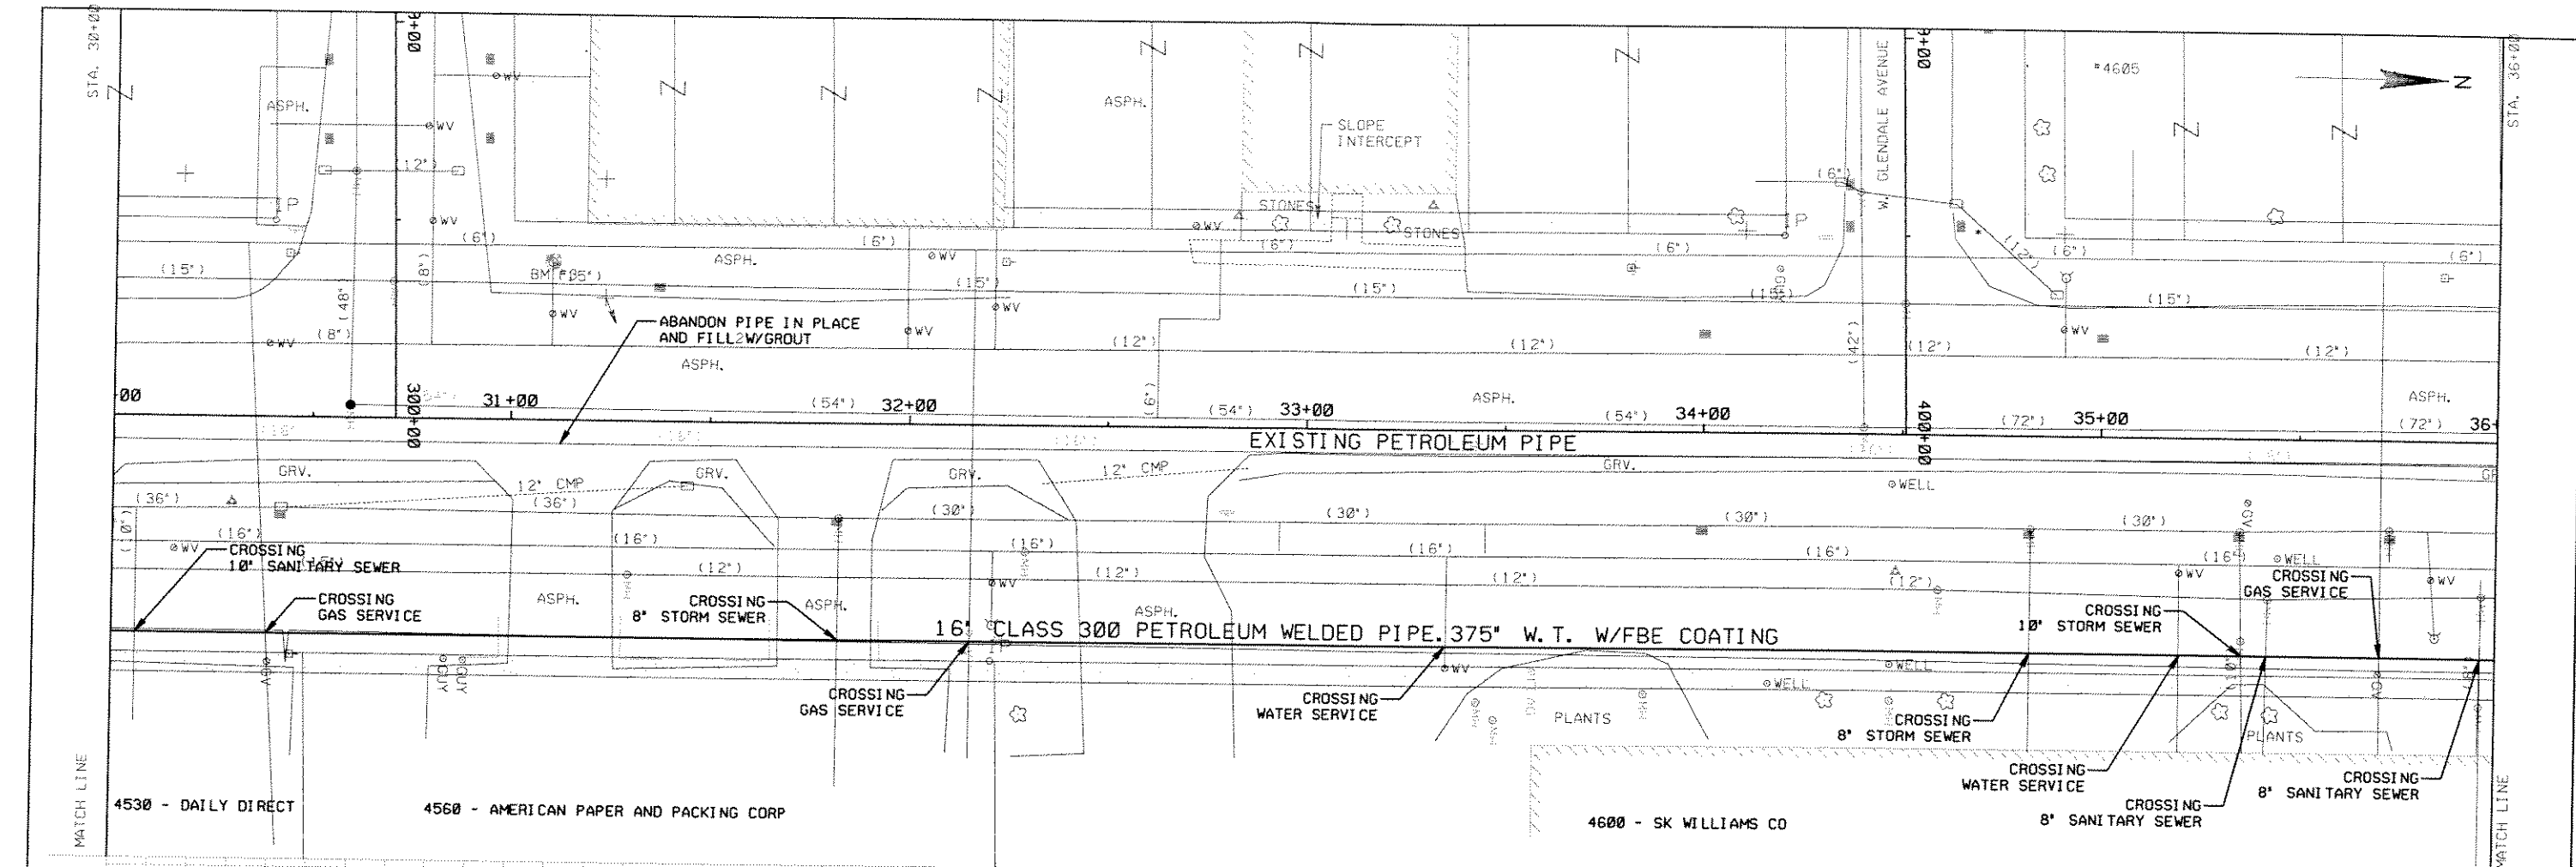

VERIFY SCALES BAR IS ONE INCH ON ORIGINAL DRAWING IF NOT ONE INCH ON THIS SHEET, ADJUST SCALES ACCORDINGLY.		CDM Camp Dresser & McKee Inc. J. KYLAR J. PRANCE M. OLESON H. FARCHMIN		WEST SHORE PIPELINE COMPANY 124TH STREET PIPELINE RELOCATION PLAN AND PROFILE STA 30+00 TO STA 36+00		DWG NO. CP-2 SHEET 2 of 5 DATE 8/04 PROJ 29187-43350 FILE CP02.dgn	
NO.	DATE	REVISION	BY	APVD			

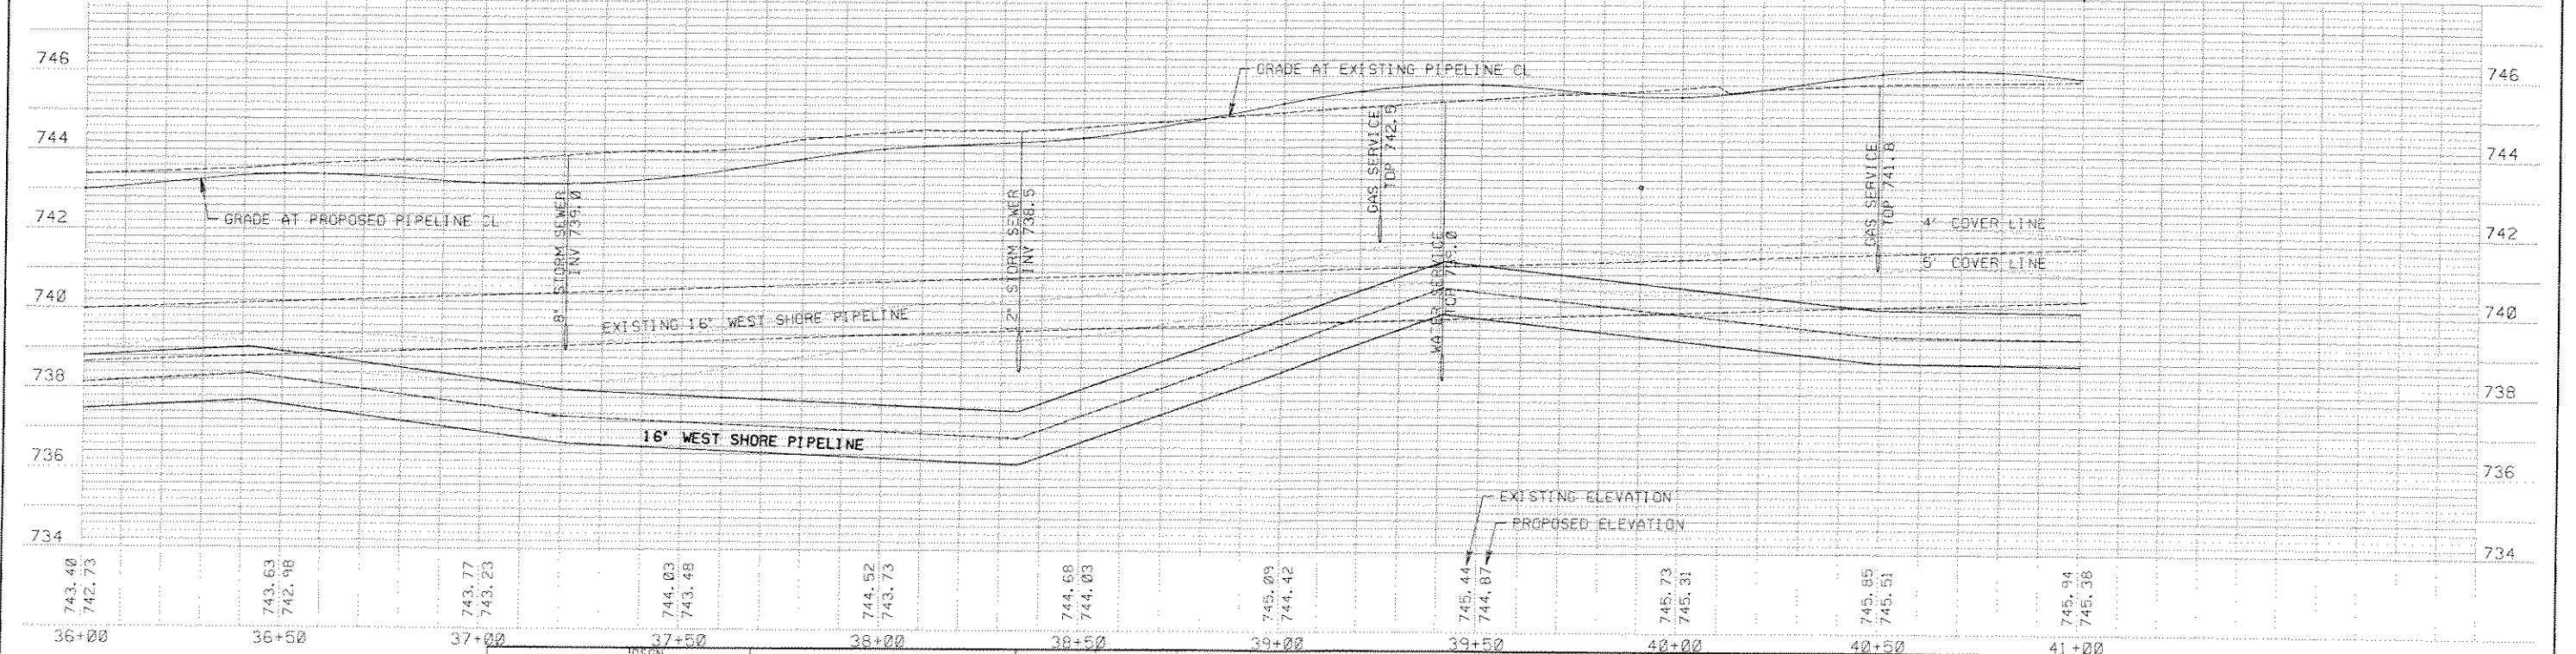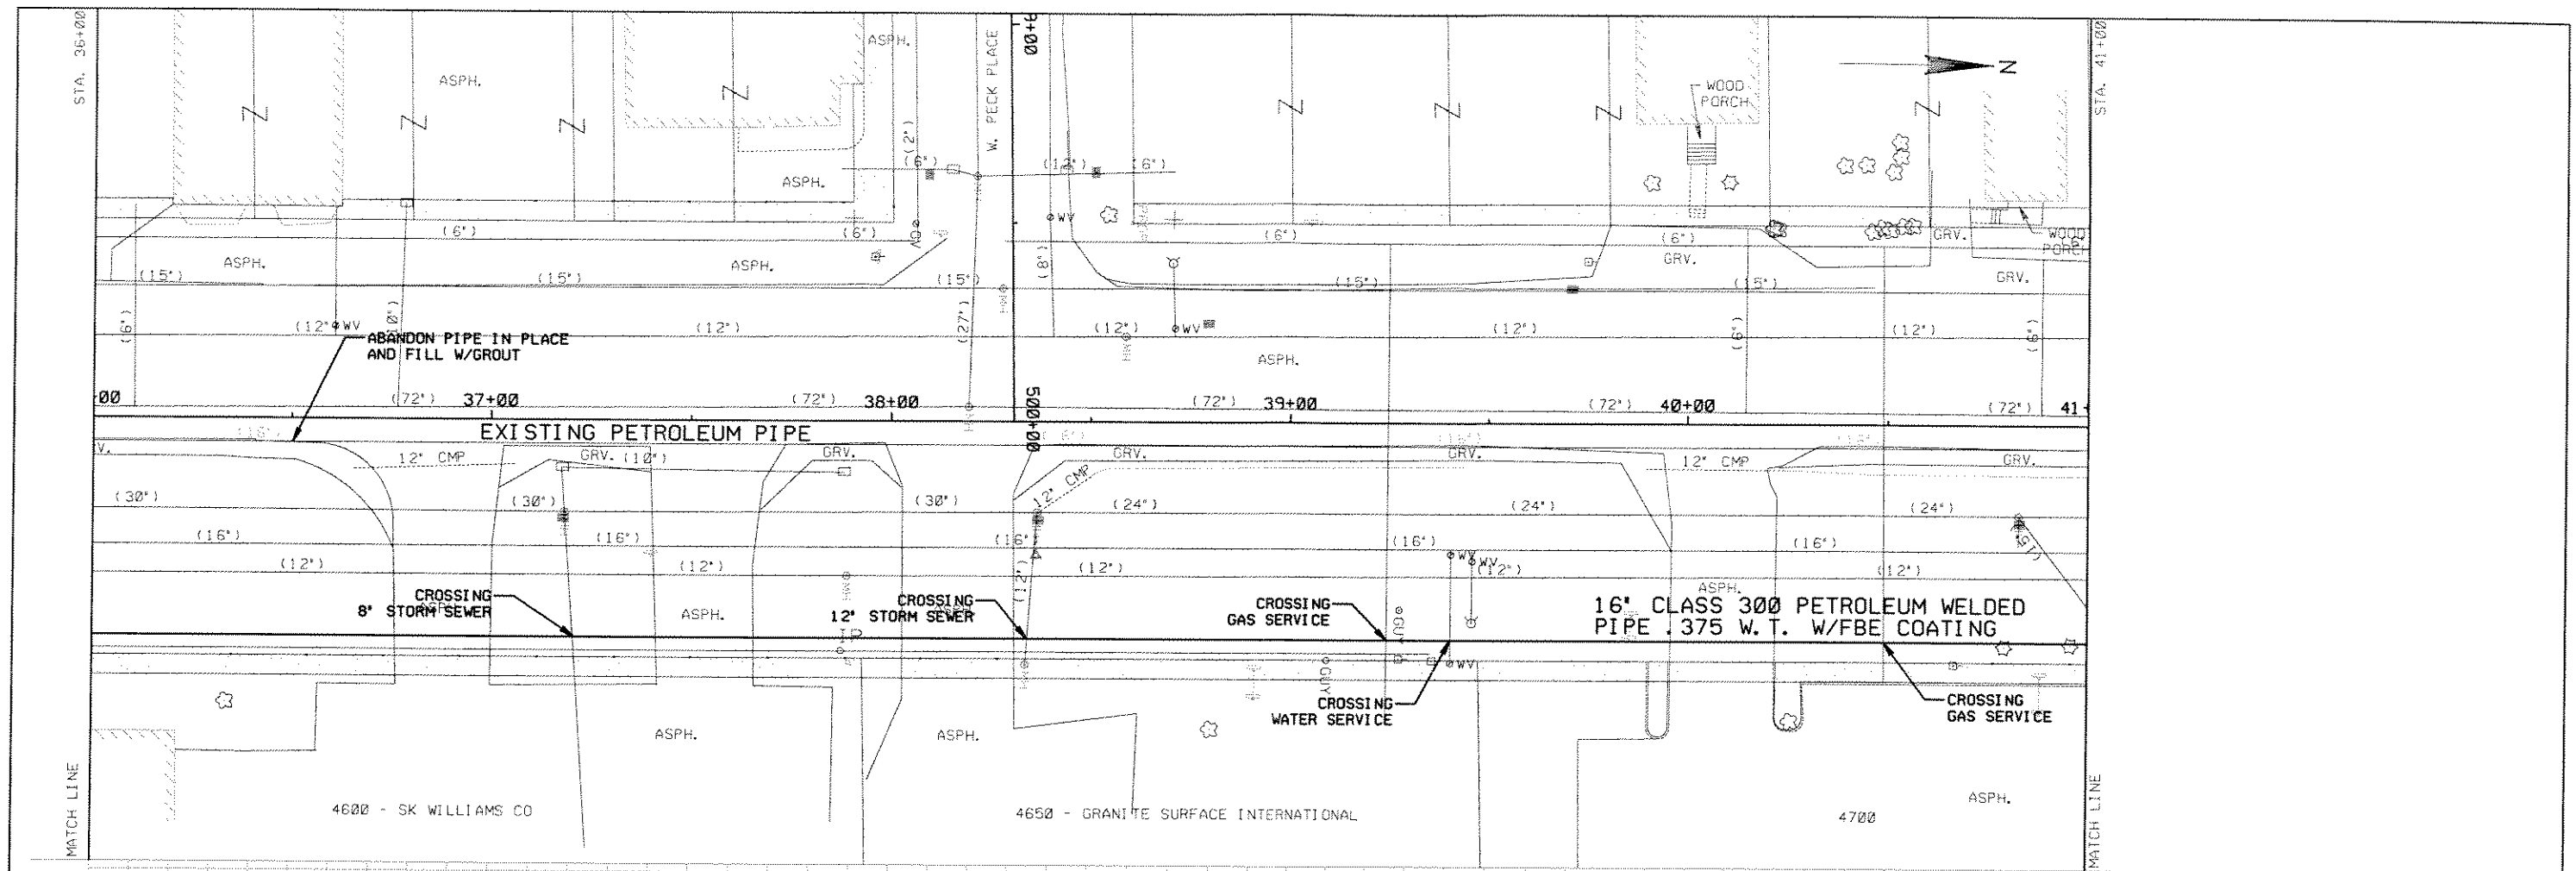

VERIFY SCALAR BAR IS ONE INCH ON ORIGINAL DRAWING IF NOT ONE INCH ON THIS SHEET, ADJUST SCALES ACCORDINGLY.		DESIGN J. KYLAR OR J. PRANGE CHK M. OLESN APVD H. FARCHMIN	CDM Camp Dresser & McKee Inc.	NO.	DATE	REVISION	BY	APVD	WEST SHORE PIPELINE COMPANY 124TH STREET PIPELINE RELOCATION PLAN AND PROFILE STA 36+00 TO STA 41+00	DWG NO. CP-3 SHEET 3 of 5 DATE 8/04 PROJ 29187-43350 FILE CP03.dgn
--	--	---	----------------------------------	-----	------	----------	----	------	---	--

