



R:\Projects\1\100\100Energy\1 - Plan\100Energy - Block 4 [M1] - 8-23-17

1  
 M1  
 SCALE: 1/8"=1'-0"  
**FIRST FLOOR HVAC LAYOUT**

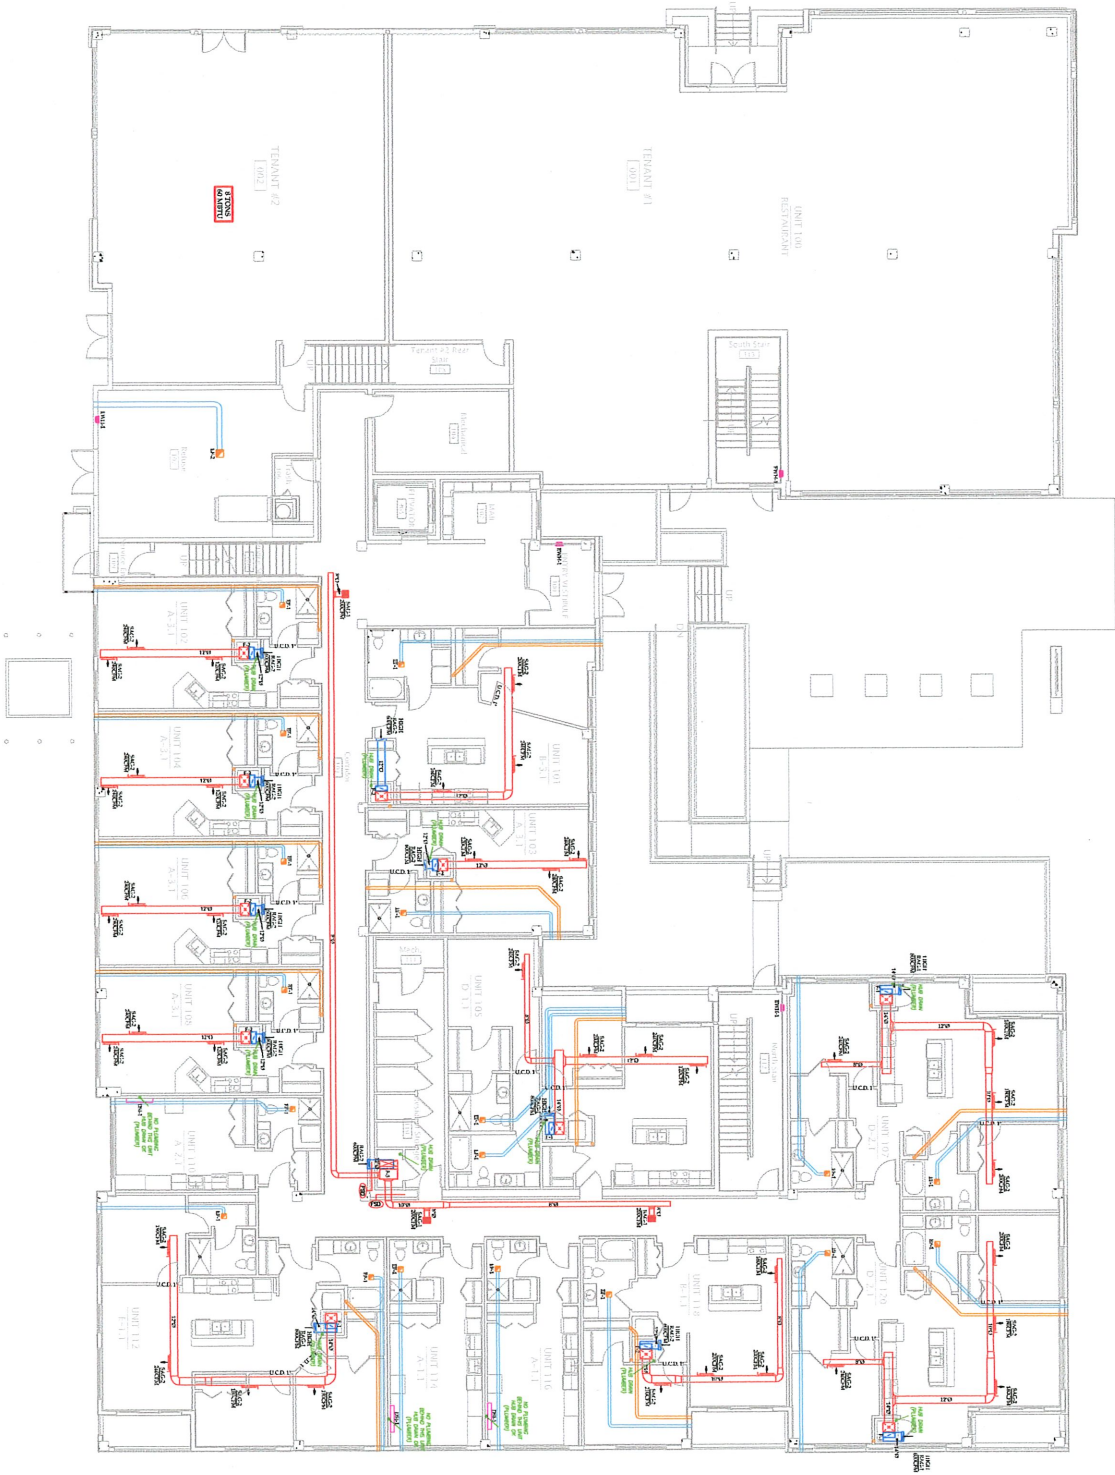

|              |                         |                  |   |  |
|--------------|-------------------------|------------------|---|--|
| <h1>M1</h1>  | Scale: 1/8" = 1'-0"     | PROJECT NAME:    | UNITS:  | <b>Dave Jones</b><br><small>PLUMBING   HEATING &amp; COOLING   FIRE PROTECTION</small><br><small>2225 Kilbuck Road, Madison, WI 53713<br/>Office: (608) 222-8490 Fax: (608) 222-8503</small> |
|              | Project Number: 1723001 | DATE DESCRIPTION | THE BREWERY - BLOCK 4<br>1210 NORTH 10TH STREET<br>MILWAUKEE, WISCONSIN 53205 |  |
| Date: 8-2-17 | PLAN CHANGES            |                  |   |  |

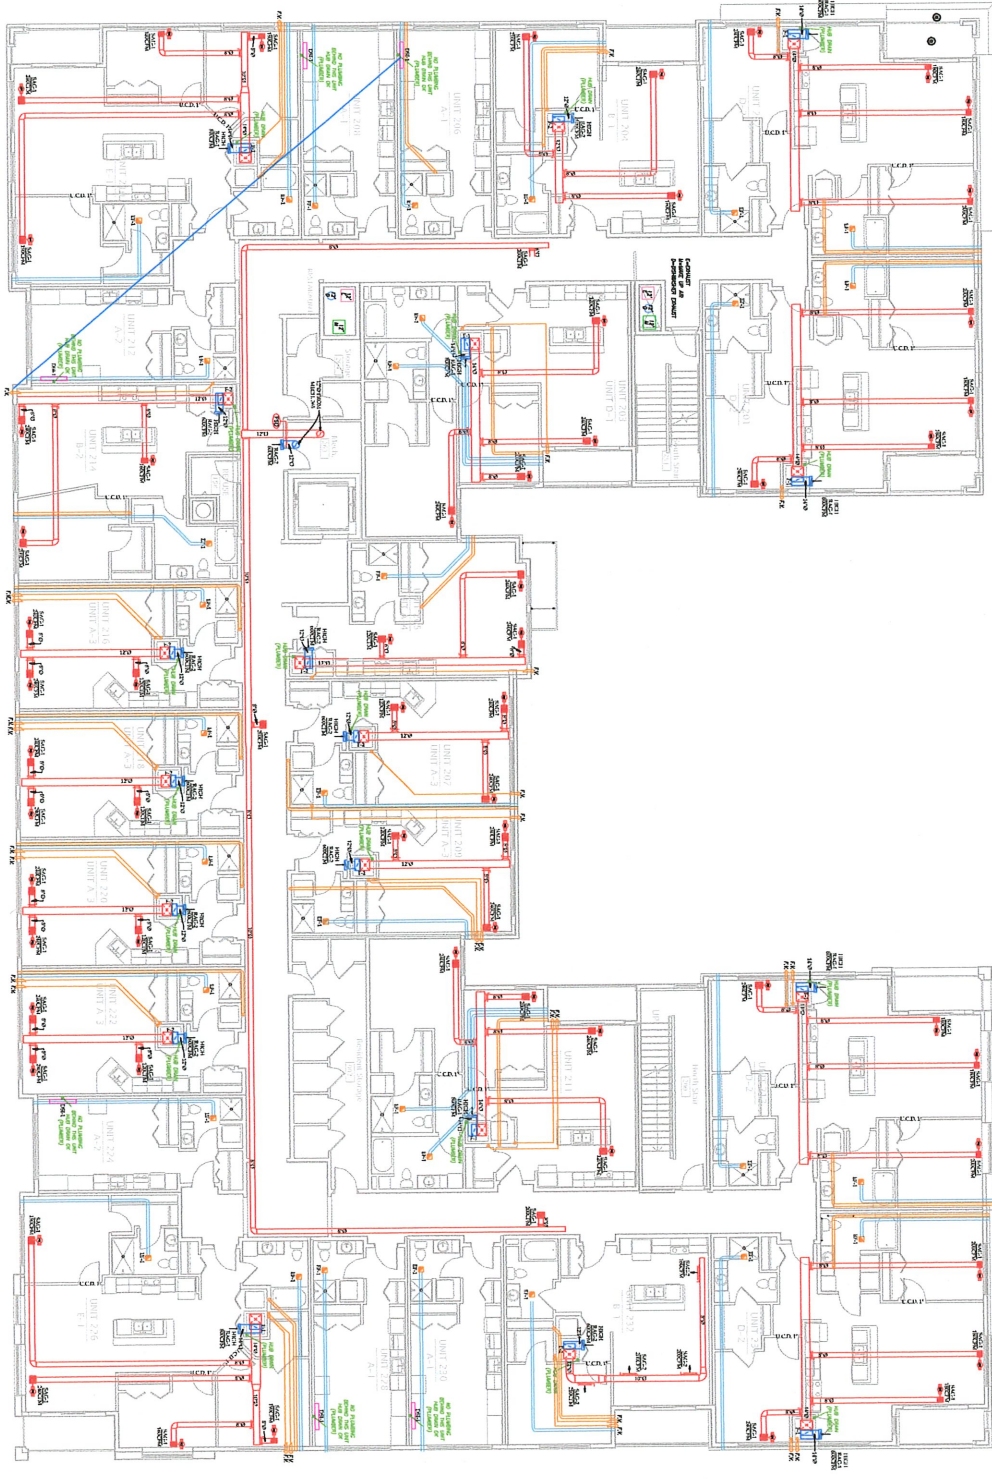

1  
M2 SCALE: 1/8" = 1'-0"  
**SECOND FLOOR HVAC LAYOUT**



UNITS:


**PROJECT NAME:**  
**THE BREWERY - BLOCK 4**  
**1210 NORTH 10TH STREET**  
**MILWAUKEE, WISCONSIN 53205**

PLAN CHANGES  
DATE DESCRIPTION

**Dave Jones**  
PLUMBING | HEATING & COOLING | FIRE PROTECTION  
2225 Kilgus Road Madison, WI 53713  
Office: (608)-222-8490 Fax: (608)-222-8503

**M2**

Scale: 1/8" = 1'-0"  
Project Number: 1723001  
Date: 8-2-17

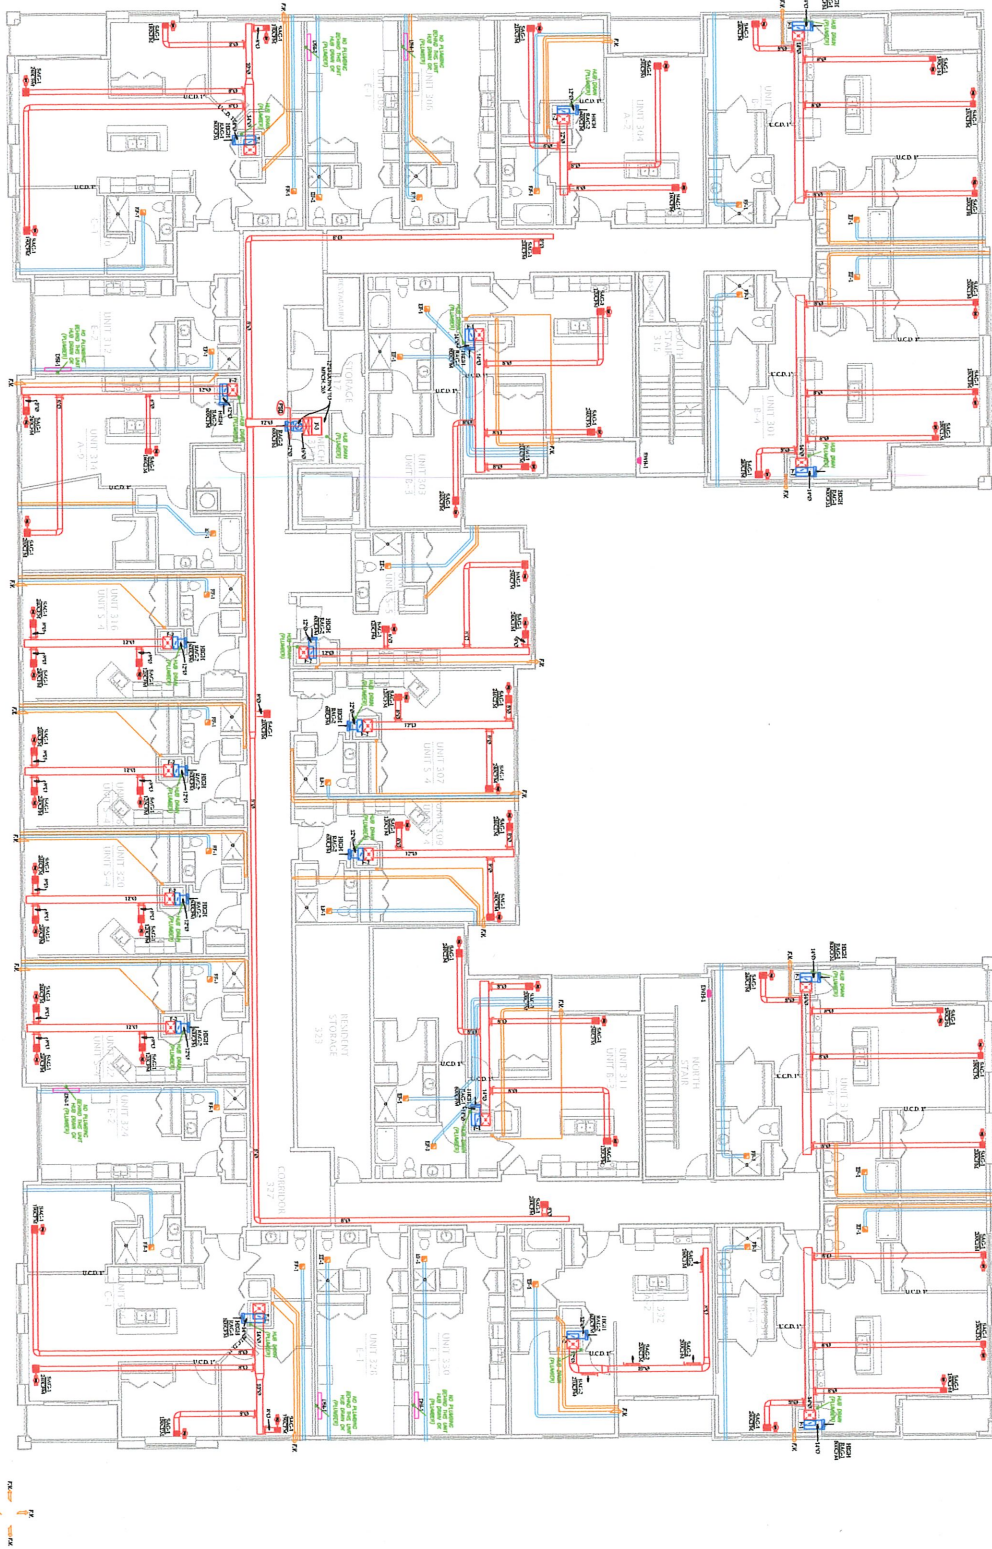


1  
**THIRD FLOOR HVAC LAYOUT**  
 M3 SCALE: 1/8"=1'-0"



M3

|                         |   |        |
|-------------------------|---|--------|
|                         | PROJECT NAME:<br><b>THE BREWERY - BLOCK 4</b><br>1210 NORTH 10TH STREET<br>MILWAUKEE, WISCONSIN 53205 | UNITS: |
| DATE DESCRIPTION        |   |        |
| PLAN CHANGES            |   |        |
| Scale: 1/8" = 1'-0"     |   |        |
| Project Number: 1722001 |   |        |
| Date: 8-3-17            |   |        |

**Dave Jones**  
 PLUMBING | HEATING & COOLING | FIRE PROTECTION  
 2225 Kilgus Road Madison, WI 53713  
 Office: (608)-222-8490 Fax: (608)-222-8503

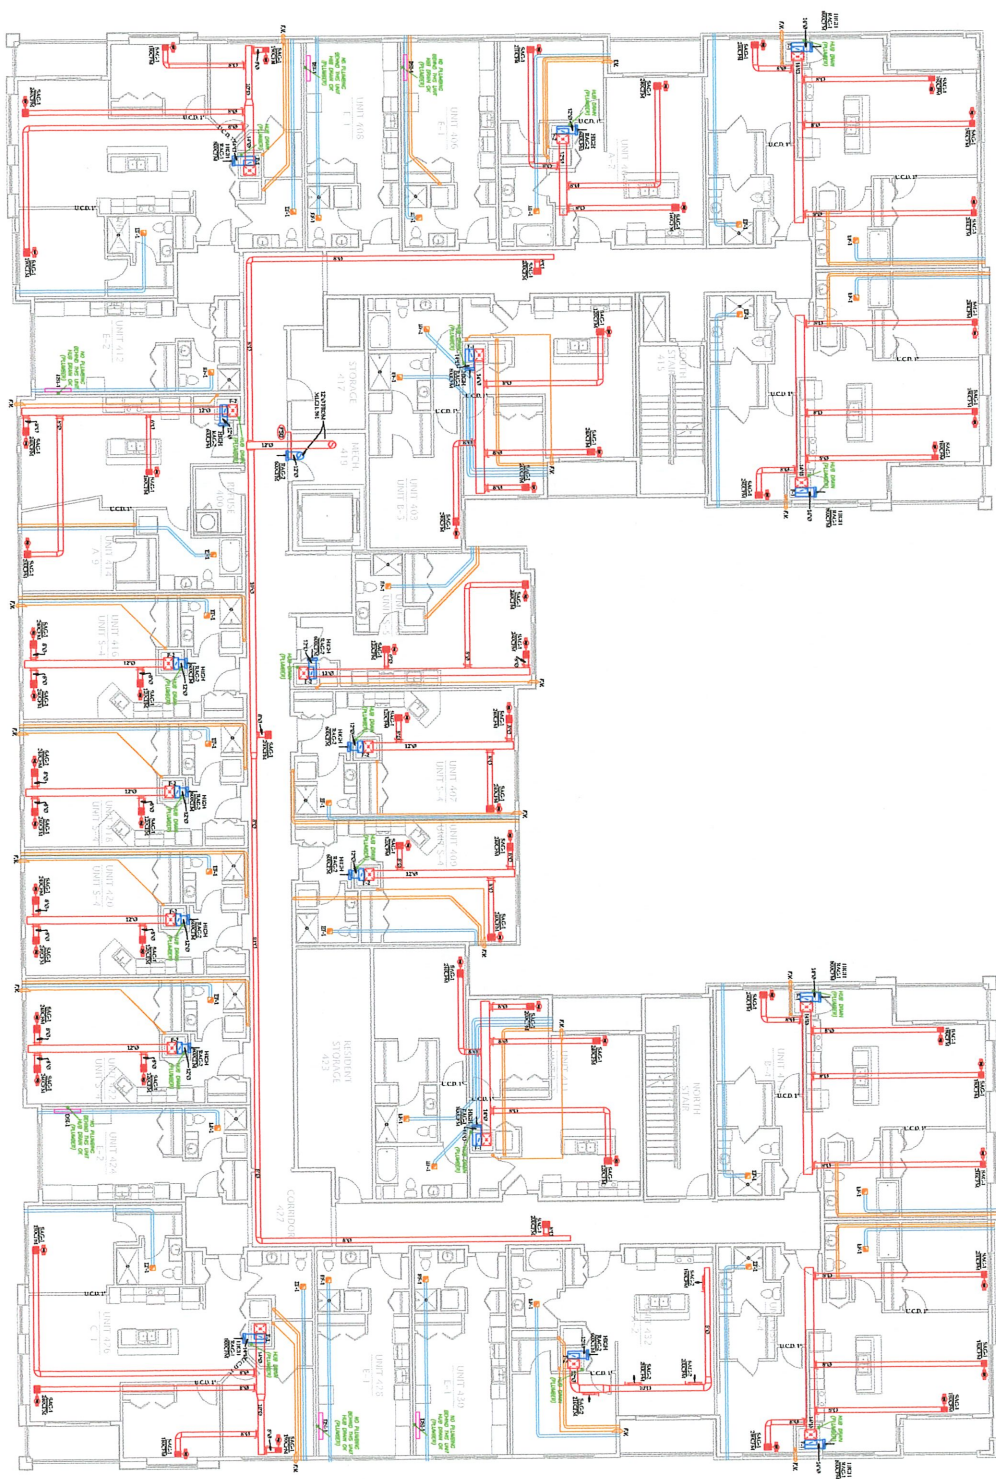

1


FOURTH FLOOR HVAC LAYOUT

SCALE: 1/8"=1'-0"



|                        |                                    |        |   |
|------------------------|------------------------------------|--------|---|
| M4                     | PROJECT NAME:                      | UNITS: | <b>Dave Jones</b><br>PLUMBING   HEATING & COOLING   FIRE PROTECTION<br>2225 Kilgus Road Madison, WI 53713<br>Office: (608)-222-8490 Fax: (608)-222-8503 |
|                        | THE BREWERY - BLOCK 4              |        |   |
|                        | 1210 NORTH 10TH STREET             |        |   |
|                        | MILWAUKEE, WISCONSIN 53205         |        |   |
| DATE   DESCRIPTION     | PLAN CHANGES<br>DATE   DESCRIPTION |        |   |
| Scale: 1/8" = 1'-0"    |                                    |        |   |
| Project Number: 172001 |                                    |        |   |
| Date: 8-2-17           |                                    |        |   |

1  
FIFTH FLOOR HVAC LAYOUT  
MS  
SCALE: 1/8"=1'-0"

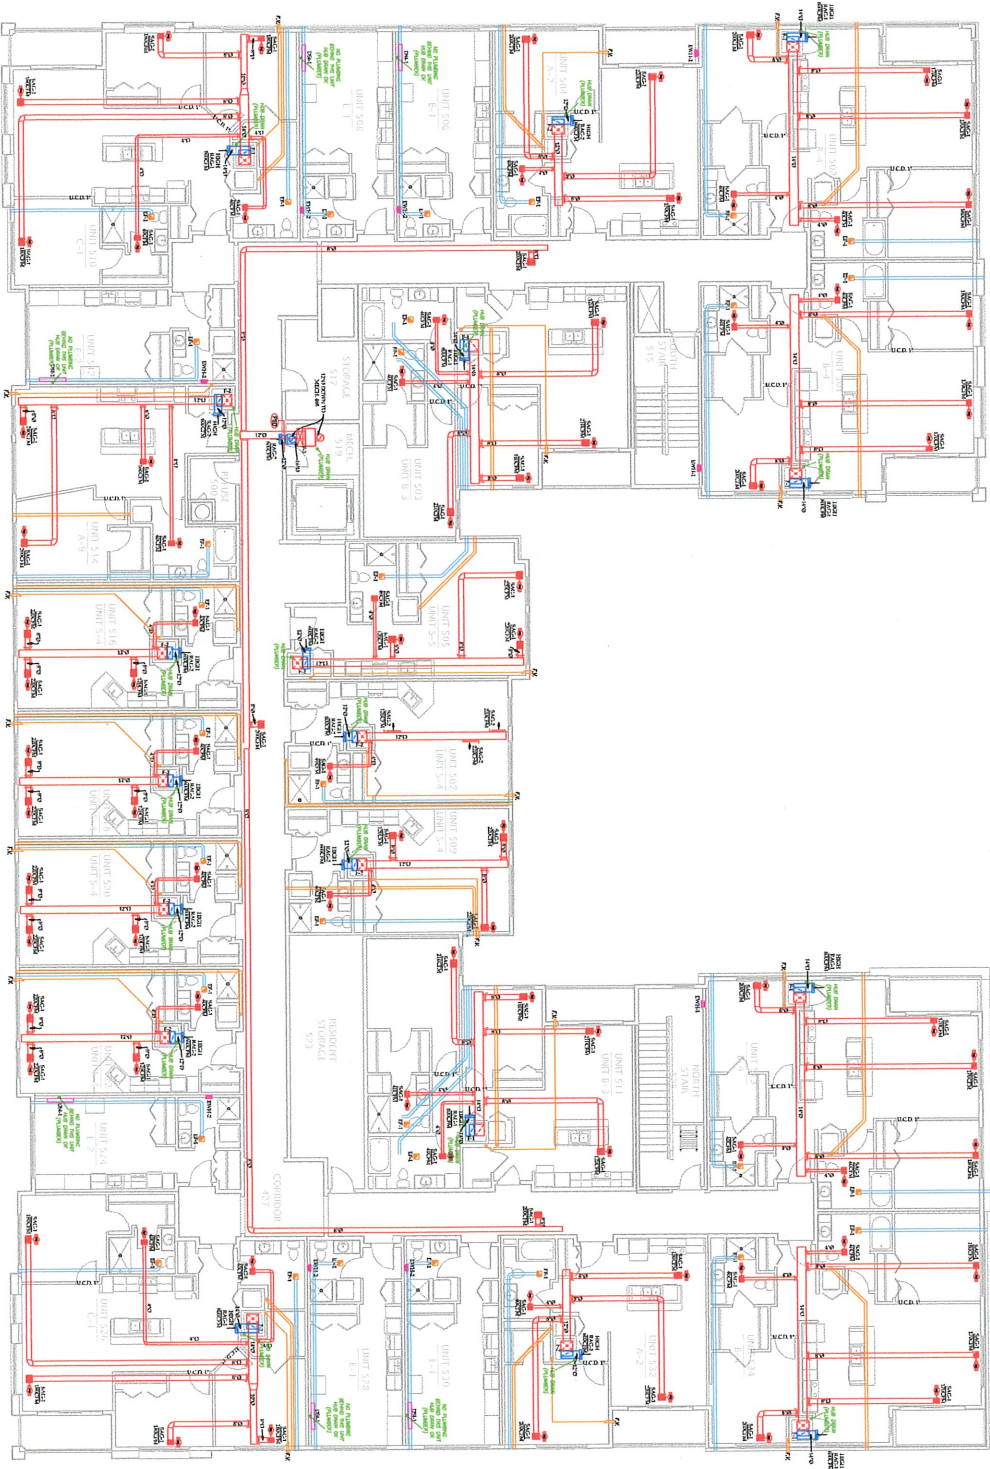

MS

Date: 8-2-17  
Project Number: 1722001  
Scale: 1/8" = 1'-0"


| PLAN CHANGES |  |  |
|--------------|--|--|
| DATE         |  |  |
| DESCRIPTION  |  |  |
|              |  |  |

PROJECT NAME:  
THE BREWERY - BLOCK 4  
1210 NORTH 10TH STREET  
MILWAUKEE, WISCONSIN 53205

UNITS:



2225 Kilgus Road Madison, WI 53713  
Office: (608)-222-8490 Fax: (608)-222-8503

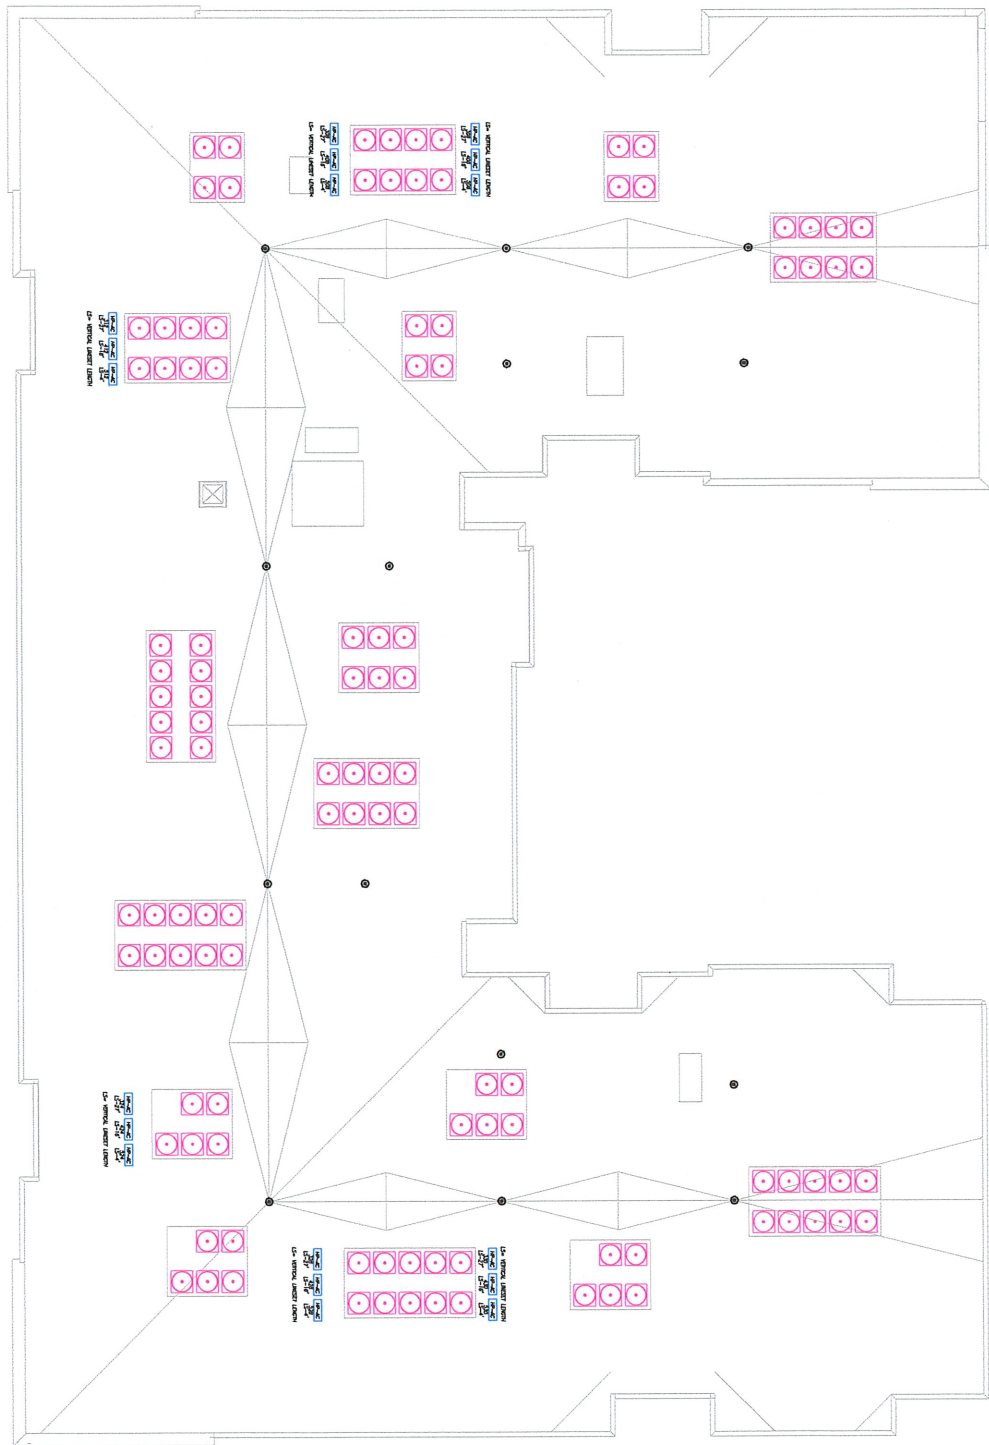

1  
M6 HVAC ROOF LAYOUT  
SCALE: 1/8"=1'-0"



M6

| PLAN CHANGES | DATE | DESCRIPTION |
|--------------|------|-------------|
|              |      |             |

PROJECT NAME:  
**THE BREWERY - BLOCK 4**  
 1210 NORTH 10TH STREET  
 MILWAUKEE, WISCONSIN 53205

UNITS:


**Dave Jones**  
 PLUMBING | HEATING & COOLING | FIRE PROTECTION

2225 Kilquist Road Madison, WI 53713  
 Office: (608) 222-8490 Fax: (608) 222-8503

Scale: 1/8" = 1'-0"


Project Number: 172001

Date: 8-2-17

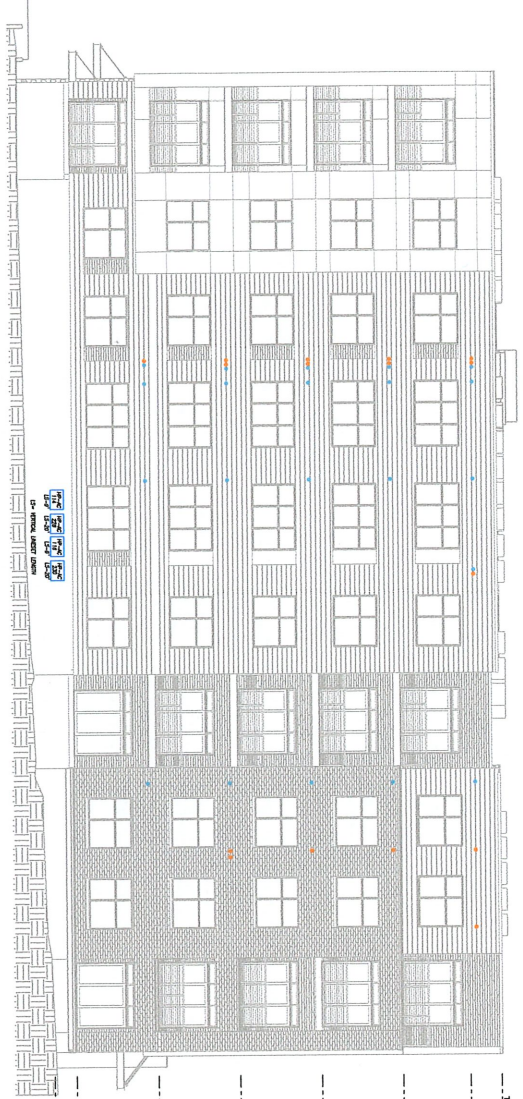

1  
NORTH ELEVATION  
SCALE: 1/8"=1'-0"

- TOP OF PARAPET - 13'-0"
- FLOOR FINISH - 12'-0"
- SECOND FLOOR FINISH - 11'-2 1/2"
- FIRST FLOOR FINISH - 10'-0"
- SECOND FLOOR FINISH - 11'-2 1/2"
- THIRD FLOOR FINISH - 12'-3 7/8"
- FOURTH FLOOR FINISH - 13'-5 7/8"
- FIFTH FLOOR FINISH - 14'-7 7/8"
- SIXTH FLOOR FINISH - 15'-9 7/8"
- METAL CEILING

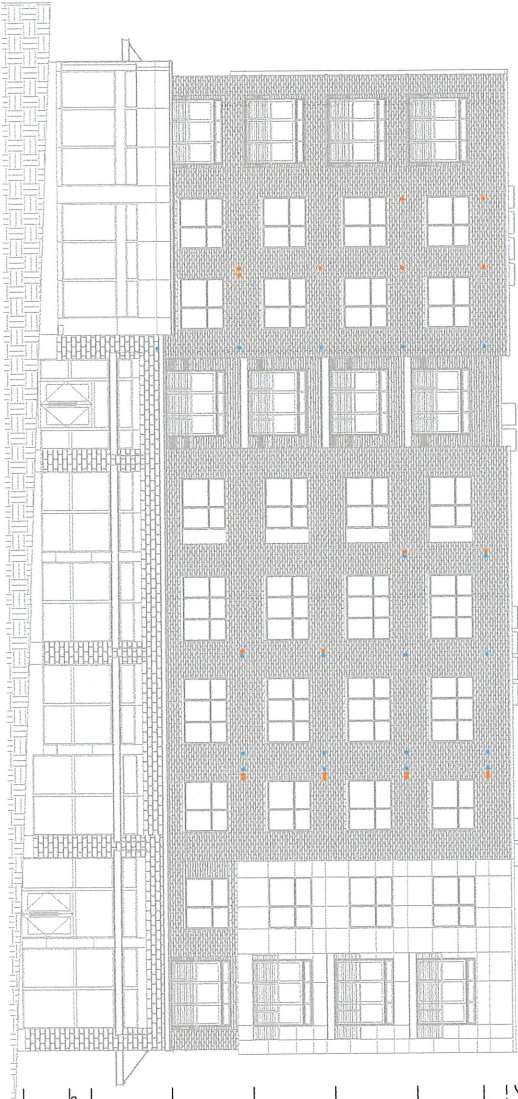

2  
SOUTH ELEVATION  
SCALE: 1/8"=1'-0"

- TOP OF PARAPET - 13'-0"
- FLOOR FINISH - 12'-0"
- FLOOR FINISH - 13'-0"
- FLOOR FINISH - 14'-0"
- FIRST FLOOR FINISH - 10'-0"
- SECOND FLOOR FINISH - 11'-2 1/2"
- THIRD FLOOR FINISH - 12'-3 7/8"
- FOURTH FLOOR FINISH - 13'-5 7/8"
- FIFTH FLOOR FINISH - 14'-7 7/8"
- METAL CEILING



M8


|                         |
|-------------------------|
| Scale: 1/8" = 1'-0"     |
| Project Number: 1722001 |
| Date: 9-14-17           |

| DATE | DESCRIPTION |
|------|-------------|
|      |             |


PROJECT NAME:  
**THE BREWERY - BLOCK 4**  
 1210 NORTH 10TH STREET  
 MILWAUKEE, WISCONSIN 53205

UNITS:

**Dave Jones**  
 PLUMBING | HEATING & COOLING | FIRE PROTECTION  
 2225 Kilgus Road Madison, WI 53713  
 Office: (608)-222-8490 Fax: (608)-222-8503

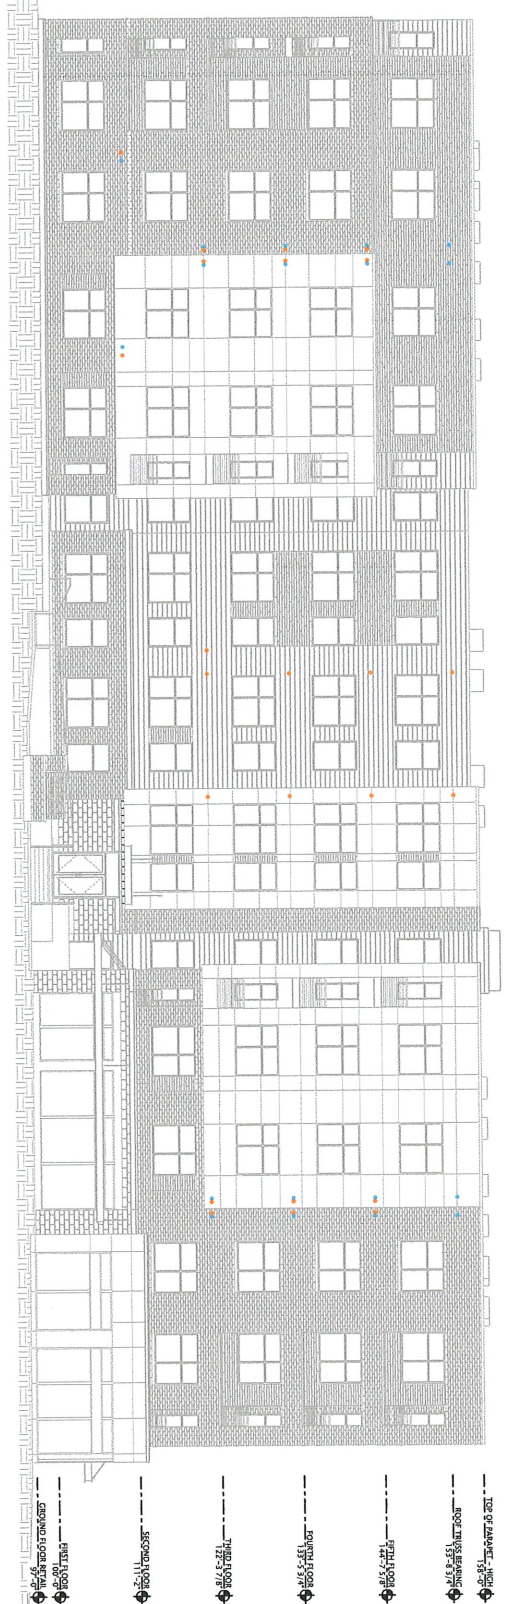

**1**  
M9  
**WEST ELEVATION**  
SCALE: 1/8"=1'-0"

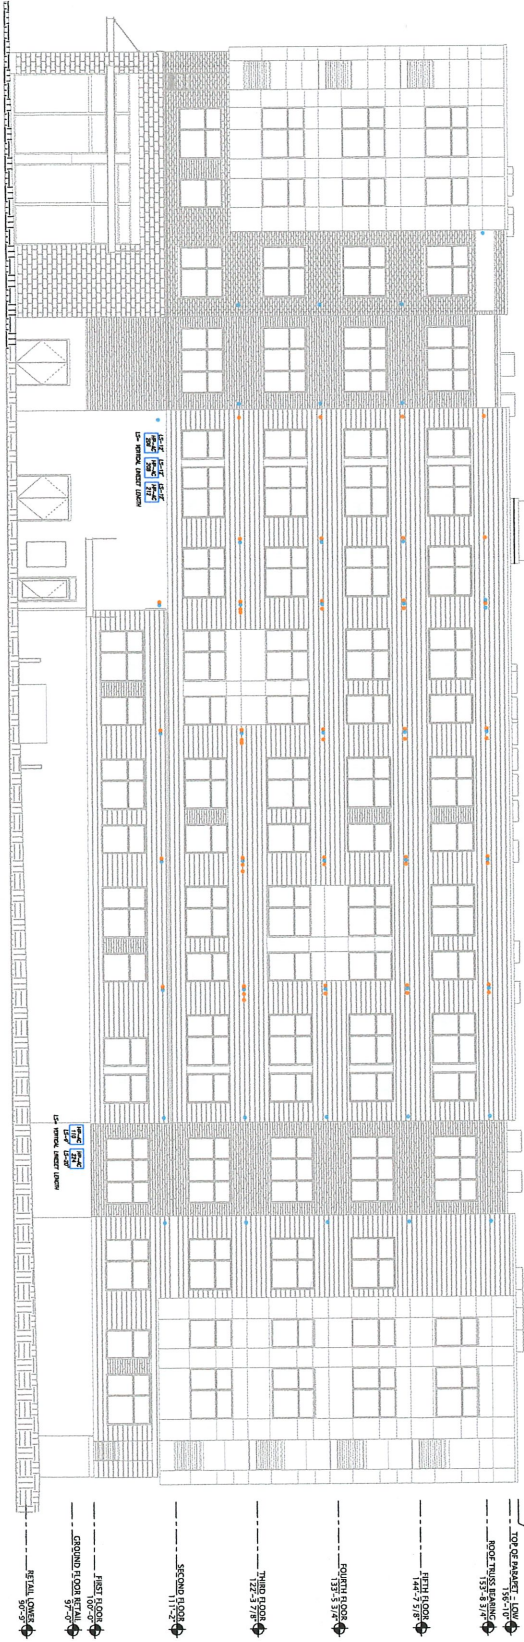

**2**  
M9  
**EAST ELEVATION**  
SCALE: 1/8"=1'-0"



- TOP OF FRAMEWORK --- 15'-0"
- 20TH FLOOR --- 15'-0" 15'-0"
- 19TH FLOOR --- 13'-0" 13'-0"
- 18TH FLOOR --- 12'-0" 12'-0"
- 17TH FLOOR --- 10'-0" 10'-0"
- 16TH FLOOR --- 8'-0" 8'-0"
- 15TH FLOOR --- 6'-0" 6'-0"
- 14TH FLOOR --- 4'-0" 4'-0"
- 13TH FLOOR --- 2'-0" 2'-0"
- 12TH FLOOR --- 0'-0" 0'-0"
- 11TH FLOOR --- 0'-0" 0'-0"
- 10TH FLOOR --- 0'-0" 0'-0"
- 9TH FLOOR --- 0'-0" 0'-0"
- 8TH FLOOR --- 0'-0" 0'-0"
- 7TH FLOOR --- 0'-0" 0'-0"
- 6TH FLOOR --- 0'-0" 0'-0"
- 5TH FLOOR --- 0'-0" 0'-0"
- 4TH FLOOR --- 0'-0" 0'-0"
- 3RD FLOOR --- 0'-0" 0'-0"
- 2ND FLOOR --- 0'-0" 0'-0"
- 1ST FLOOR --- 0'-0" 0'-0"
- 0TH FLOOR --- 0'-0" 0'-0"
- FINISHED 1ST FLOOR --- 0'-0" 0'-0"
- FINISHED 2ND FLOOR --- 0'-0" 0'-0"
- FINISHED 3RD FLOOR --- 0'-0" 0'-0"
- FINISHED 4TH FLOOR --- 0'-0" 0'-0"
- FINISHED 5TH FLOOR --- 0'-0" 0'-0"
- FINISHED 6TH FLOOR --- 0'-0" 0'-0"
- FINISHED 7TH FLOOR --- 0'-0" 0'-0"
- FINISHED 8TH FLOOR --- 0'-0" 0'-0"
- FINISHED 9TH FLOOR --- 0'-0" 0'-0"
- FINISHED 10TH FLOOR --- 0'-0" 0'-0"
- FINISHED 11TH FLOOR --- 0'-0" 0'-0"
- FINISHED 12TH FLOOR --- 0'-0" 0'-0"
- FINISHED 13TH FLOOR --- 0'-0" 0'-0"
- FINISHED 14TH FLOOR --- 0'-0" 0'-0"
- FINISHED 15TH FLOOR --- 0'-0" 0'-0"
- FINISHED 16TH FLOOR --- 0'-0" 0'-0"
- FINISHED 17TH FLOOR --- 0'-0" 0'-0"
- FINISHED 18TH FLOOR --- 0'-0" 0'-0"
- FINISHED 19TH FLOOR --- 0'-0" 0'-0"
- FINISHED 20TH FLOOR --- 0'-0" 0'-0"
- FINISHED ROOF --- 0'-0" 0'-0"

|           |   |
|-----------|---|
| <b>M9</b> | Scale: 1/8" = 1'-0"                     |
|           | Project Number: 172001<br>Date: 9-14-17 |


| DATE | DESCRIPTION |
|------|-------------|
|      |             |
|      |             |

**PROJECT NAME:**  
**THE BREWERY - BLOCK 4**  
 1210 NORTH 10TH STREET  
 MILWAUKEE, WISCONSIN 53205

UNITS:

**Dave Jones**  
 PLUMBING | HEATING & COOLING | FIRE PROTECTION  
 2225 Kilgus Road Madison, WI 53713  
 Office: (608)-222-8490 Fax: (608)-222-8503




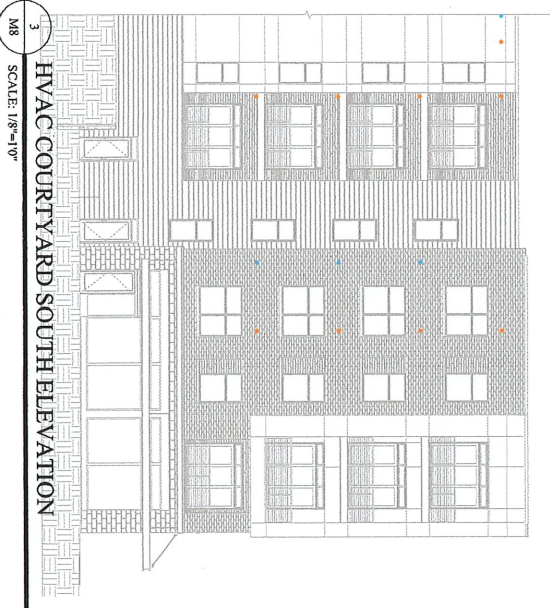

**3**  
 HVAC COURTYARD SOUTH ELEVATION  
 SCALE: 1/8"=10"



**2**  
 HVAC COURTYARD NORTH ELEVATION  
 SCALE: 1/8"=10"

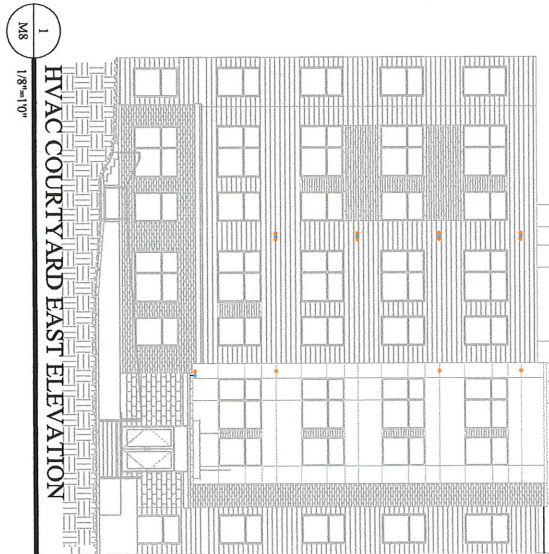

**1**  
 HVAC COURTYARD EAST ELEVATION  
 SCALE: 1/8"=10"

**M8**

Scale: 1/8"=10"  
 Project Number: 172801  
 Date: 9-15-17

PLAN CHANGES  
 DATE DESCRIPTION

PROJECT NAME:  
**THE BREWERY - BLOCK 4**  
**1210 NORTH 10TH STREET**  
**MILWAUKEE, WISCONSIN 53205**

UNITS:

**Dave Jones**  
 PLUMBING | HEATING & COOLING | FIRE PROTECTION  
 2225 Kilgus Road Madison, WI 53713  
 Office: (608) 222-8490 Fax: (608) 222-8503