

This document is owned by and the information contained in it is proprietary to Poblocki Sign Company, LLC. By receipt hereof, the holder agrees not to use the information, disclose it to any third party or reproduce this document without the prior written consent of Poblocki Sign Company, LLC. Holder also agrees to immediately return this document upon request by Poblocki Sign Company, LLC.

This document represents only an approximation of material colors specified. Actual product colors may vary from this print or digital image.

**Project**

**Educators Credit Union**  
**Aurora Forest Home Business Center**

Milwaukee, Wisconsin

Scale: NTS

Original Page Size: 11" x 17"

**Notes**

.

**Revisions**

REV	DESCRIPTION	BY	DATE
01	remove 2 sign locs	sew	09.06.18
02	sign loc/addt. signs	sew	09.10.18
03	sign removals	sew	10.08.18

Rep.: Matt Kaminski

Drawn By: Sarah Watson Orig. Date: 08/21/18

Sign Loc. No. .

**00**


Site Plan  
Sign. Type

**83135**

OPP - Project - Job No.

**C01**

Design

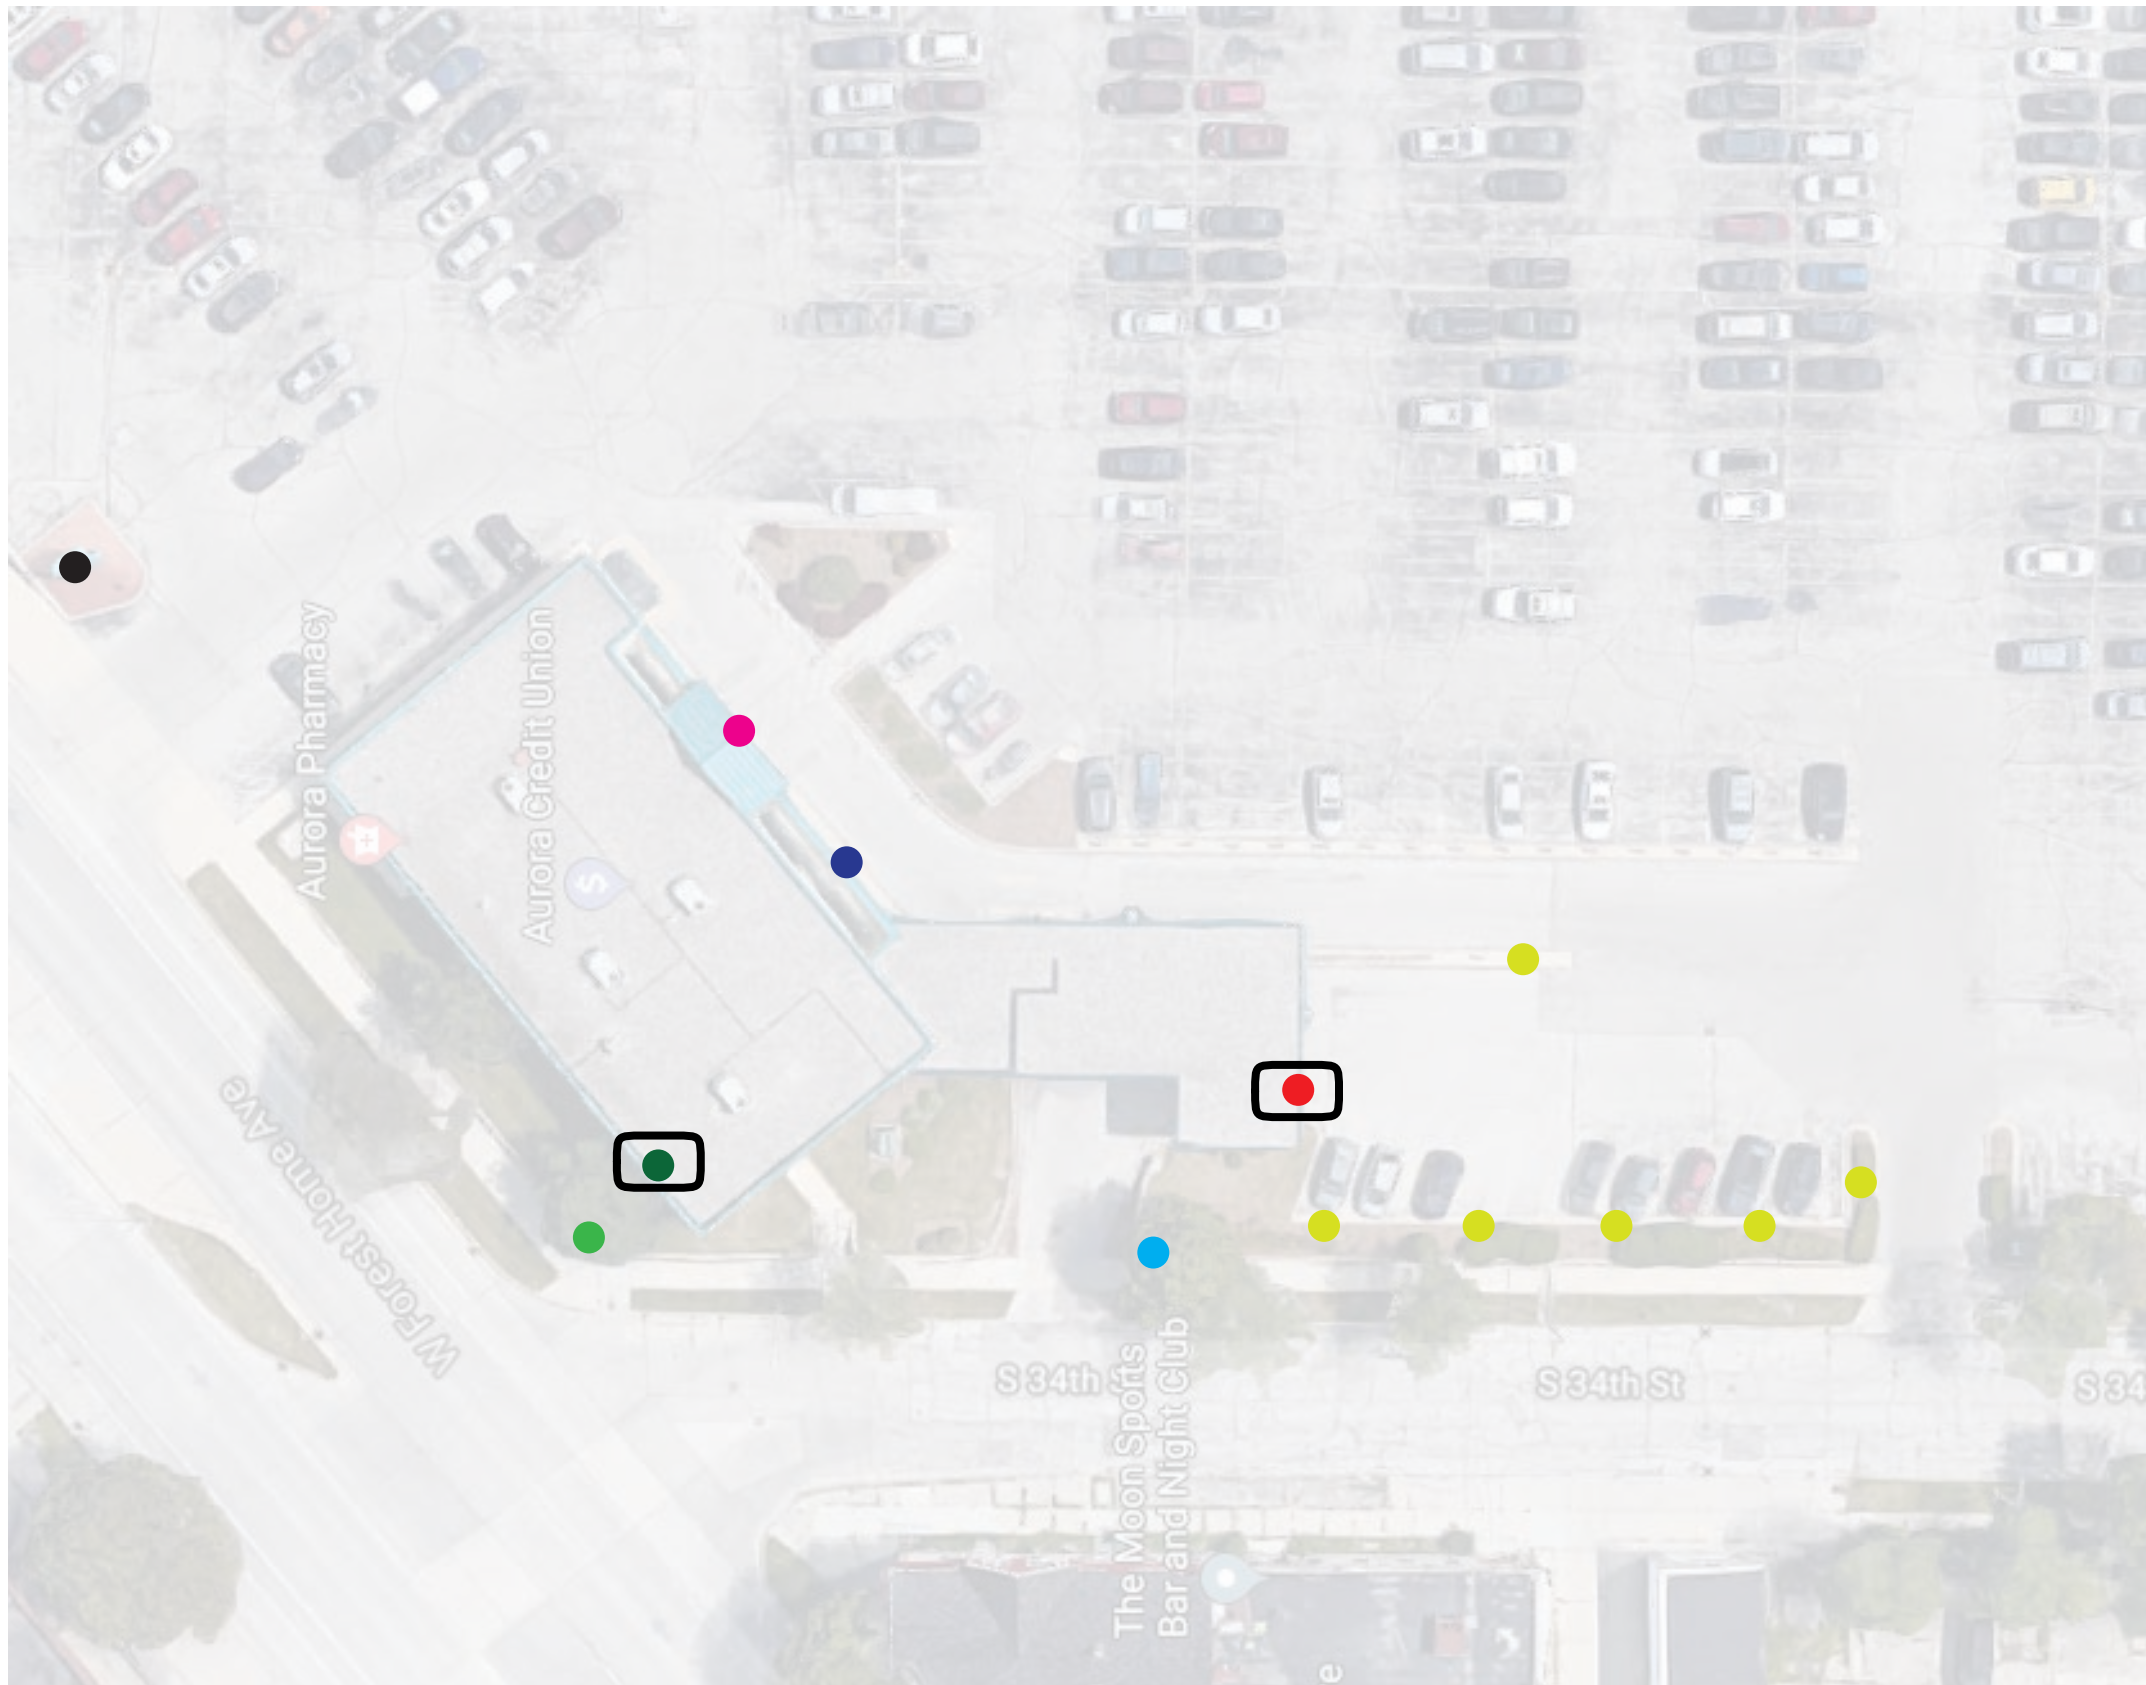

2-4-19 Need Minor Modification to DPD for two sets of lit letters

SIGN TYPE	
●	FP-01 - FLAT PANELS
●	FP-02 - FLAT PANELS
●	FP-03 - FLAT PANELS
●	NL-01 - NON-LIT LETTERS
✓ ●	LL-01-01 - LIT LETTERS
✓ ●	LL-01-02 - LIT LETTERS
●	VIN-01 - EXTERIOR VINYL

# SIGN SPECIFICATIONS

Lighting: LED  
Voltage: 1.96 amps @ 120/277 volts

**[A] - ILLUMINATED LOGO CABINET**

Description: Face-Lit [Acrylic]  
Depth: 3"  
Face Color: White with Rust Brown 3630-63 vinyl  
Return Color: White  
Trimcap Color: White  
Installation: Raceway

**[B] - ILLUMINATED LETTERS**

Description: Face-Lit [Acrylic]  
Depth: 3"  
Face Color: White  
Return Color: White  
Trimcap Color: White  
Installation: Raceway


**[C] - RACEWAY**

Color: Paint to match MP13067 Craneville Green

**Note\*** Color match is above. Actual paint color for building has been requested.




proposed layout - day view

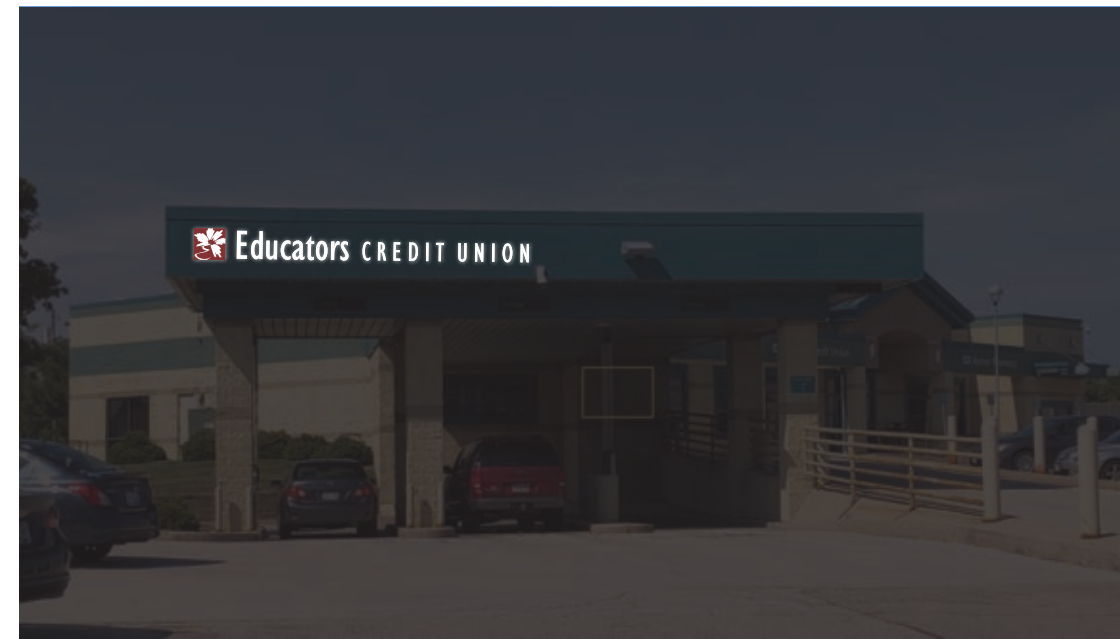

proposed layout - night view

32.78 sq'

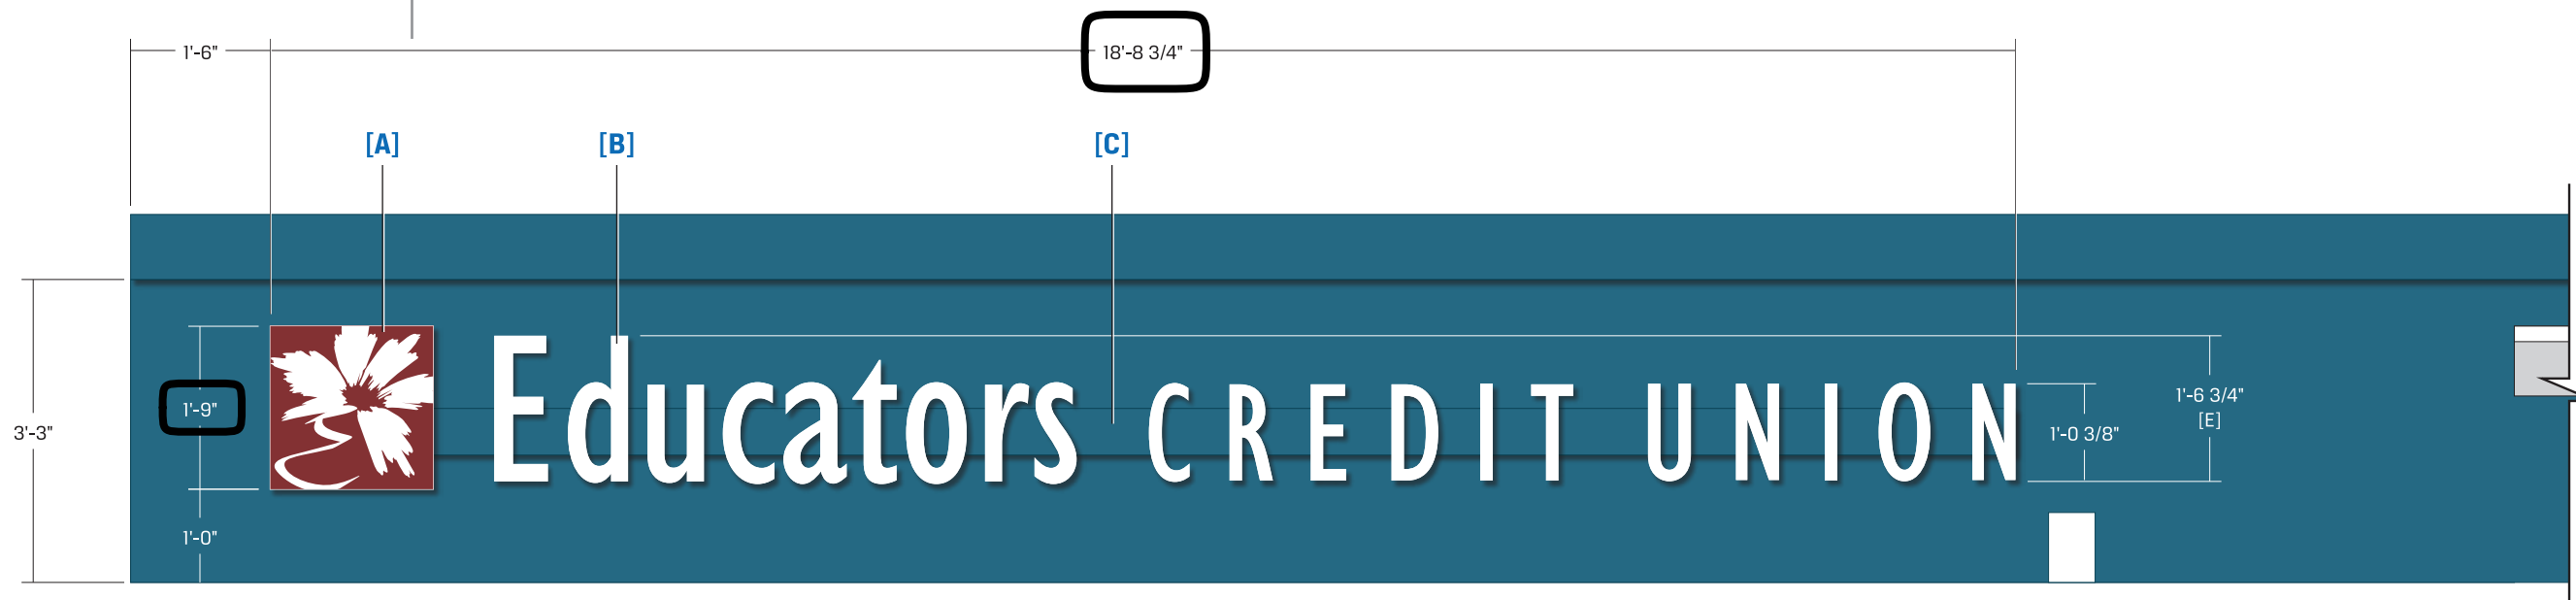

This document is owned by and the information contained in it is proprietary to Poblocki Sign Company, LLC. By receipt hereof, the holder agrees not to use the information, disclose it to any third party or reproduce this document without the prior written consent of Poblocki Sign Company, LLC. Holder also agrees to immediately return this document upon request by Poblocki Sign Company, LLC.

This document represents only an approximation of material colors specified. Actual product colors may vary from this print or digital image.

**Project**

**Educators Credit Union**  
**Aurora Forest Home Business Center**  
Milwaukee, Wisconsin

Scale: 1/2"=1'  
Original Page Size: 11" x 17"

**Notes**

CONFIRM RACEWAY COLOR

**Revisions**

REV	DESCRIPTION	DATE
01	add raceway	sew 09.06.18
02	logo color added	sew 10.04.18
03	Pre-Prod Update	JJ 11/01/18
04	night view	sew 12.17.18

Rep: Matt Kaminski  
Drawn By: Sarah Watson Orig. Date: 08/21/18

Sign Loc. No. 01

**LL-01**  
Lit Letters  
Sign. Type

**83135**  
OPP - Project - Job No.

**J01**  
Design

# SIGN SPECIFICATIONS

Lighting: LED  
Voltage: 1.96 amps @ 120/277 volts

## [A] - ILLUMINATED LOGO CABINET

Description: Face-Lit [Acrylic]  
Depth: 3"  
Face Color: White with Rust Brown 3630-63 vinyl  
Return Color: White  
Trimcap Color: White  
Installation: Raceway

## [B] - ILLUMINATED LETTERS

Description: Face-Lit [Acrylic]  
Depth: 3"  
Face Color: White  
Return Color: White  
Trimcap Color: White  
Installation: Raceway


## [C] - RACEWAY

Color: Paint to match MP13067 Craneville Green. Electric on left end of raceway.

**Note\*** Color match is above. Actual paint color for building has been requested.



proposed condition - day view

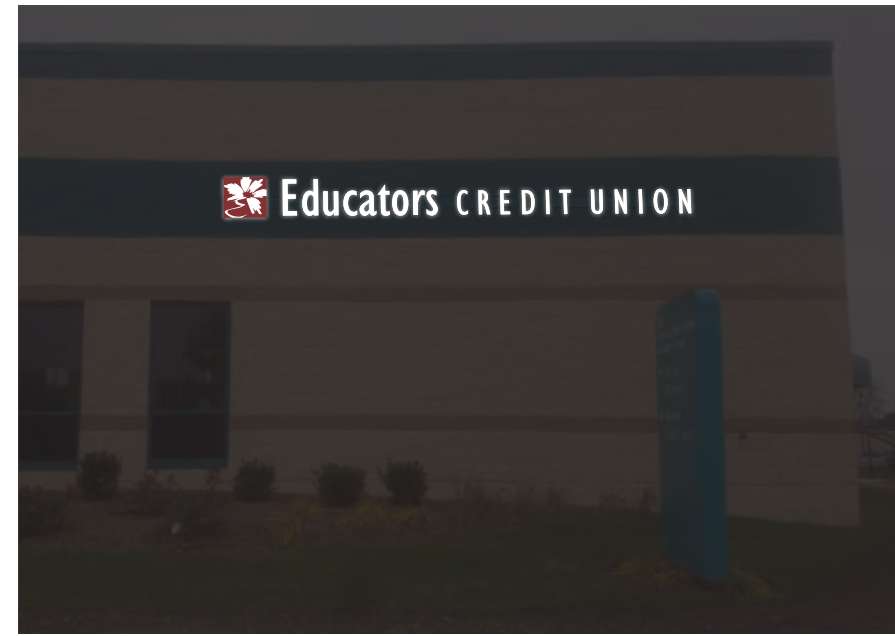


proposed condition - night view



existing condition

32.78 sq'

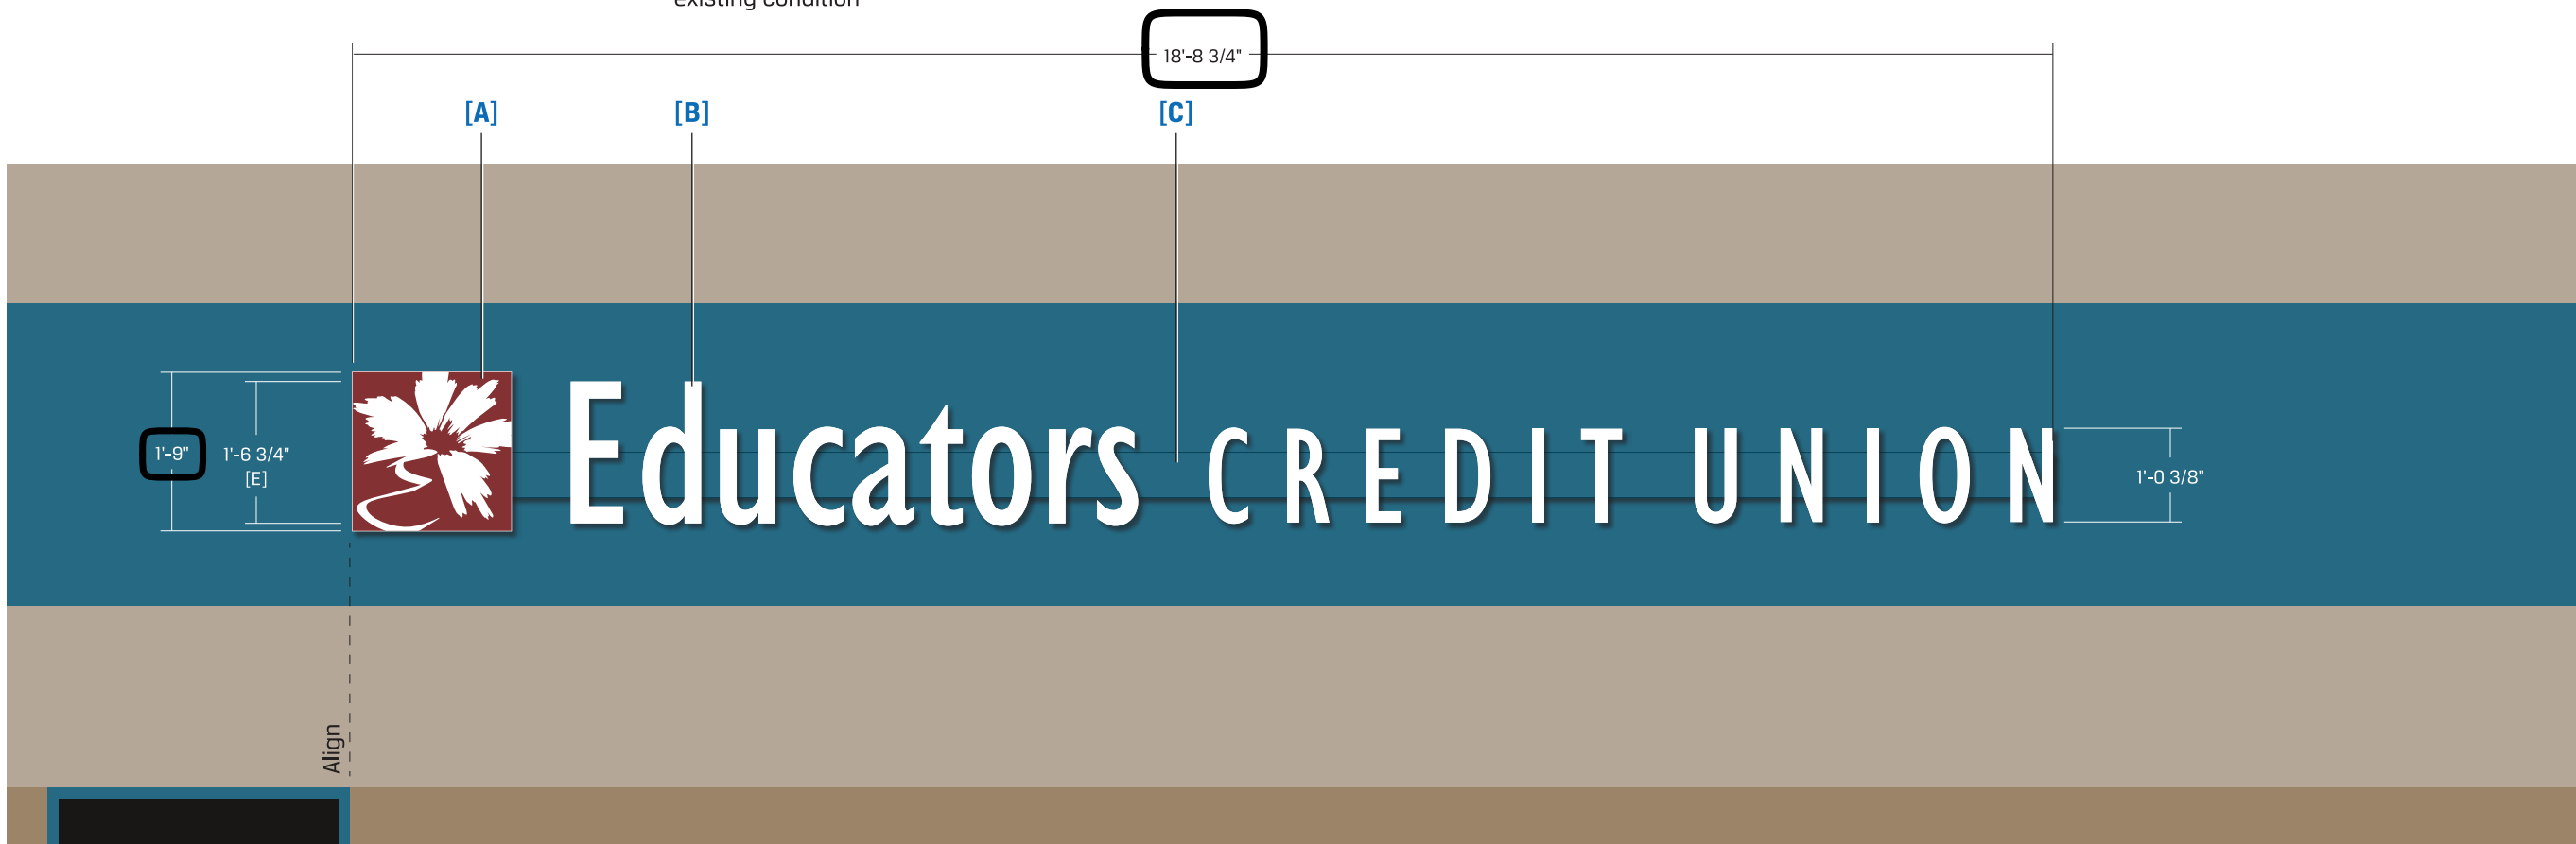

This document is owned by and the information contained in it is proprietary to Poblocki Sign Company, LLC. By receipt hereof, the holder agrees not to use the information, disclose it to any third party or reproduce this document without the prior written consent of Poblocki Sign Company, LLC. Holder also agrees to immediately return this document upon request by Poblocki Sign Company, LLC.

This document represents only an approximation of material colors specified. Actual product colors may vary from this print or digital image.

## Project

**Educators Credit Union**  
**Aurora Forest Home Business Center**

Milwaukee, Wisconsin

Scale: 1/2"=1'

Original Page Size: 11" x 17"

## Notes

**CONFIRM RACEWAY COLOR**

## Revisions

REV	DESCRIPTION	BY	DATE
01	add raceway	sew	09.06.18
02	logo color added	sew	10.04.18
03	Pre-Prod Update	JJ	11/01/18
04	night view	sew	12.17.18

Rep.: Matt Kaminski

Drawn By: Sarah Watson Orig. Date: 08/21/18

Sign Loc. No. 02

**LL-01**

Lit Letters  
Sign. Type

**83135**

OPP - Project - Job No.

**J01**

Design

This document is owned by and the information contained in it is proprietary to Poblocki Sign Company, LLC. By receipt hereof, the holder agrees not to use the information, disclose it to any third party or reproduce this document without the prior written consent of Poblocki Sign Company, LLC. Holder also agrees to immediately return this document upon request by Poblocki Sign Company, LLC.

This document represents only an approximation of material colors specified. Actual product colors may vary from this print or digital image.

**Project**  
**EDUCATORS CREDIT UNION**  
**AURORA FOREST HOME**  
BUSINESS CENTER  
MILWAUKEE, WI

Scale: **AS NOTED**  
Original Page Size: **11 x 17**

**Notes**

**Revisions**

REV	DESCRIPTION	BY	DATE
X	X	X	X

Rep.: **MATT KAMINSKI** Orig. Date: **10/29/18**  
Drawn By: **RYAN TRAPP**

**Sign Loc. No.**

**LL-01**

RACEWAY LETTER


Sign Type

**83135**


OPP-Project-Job No.

**S01**

Sheet

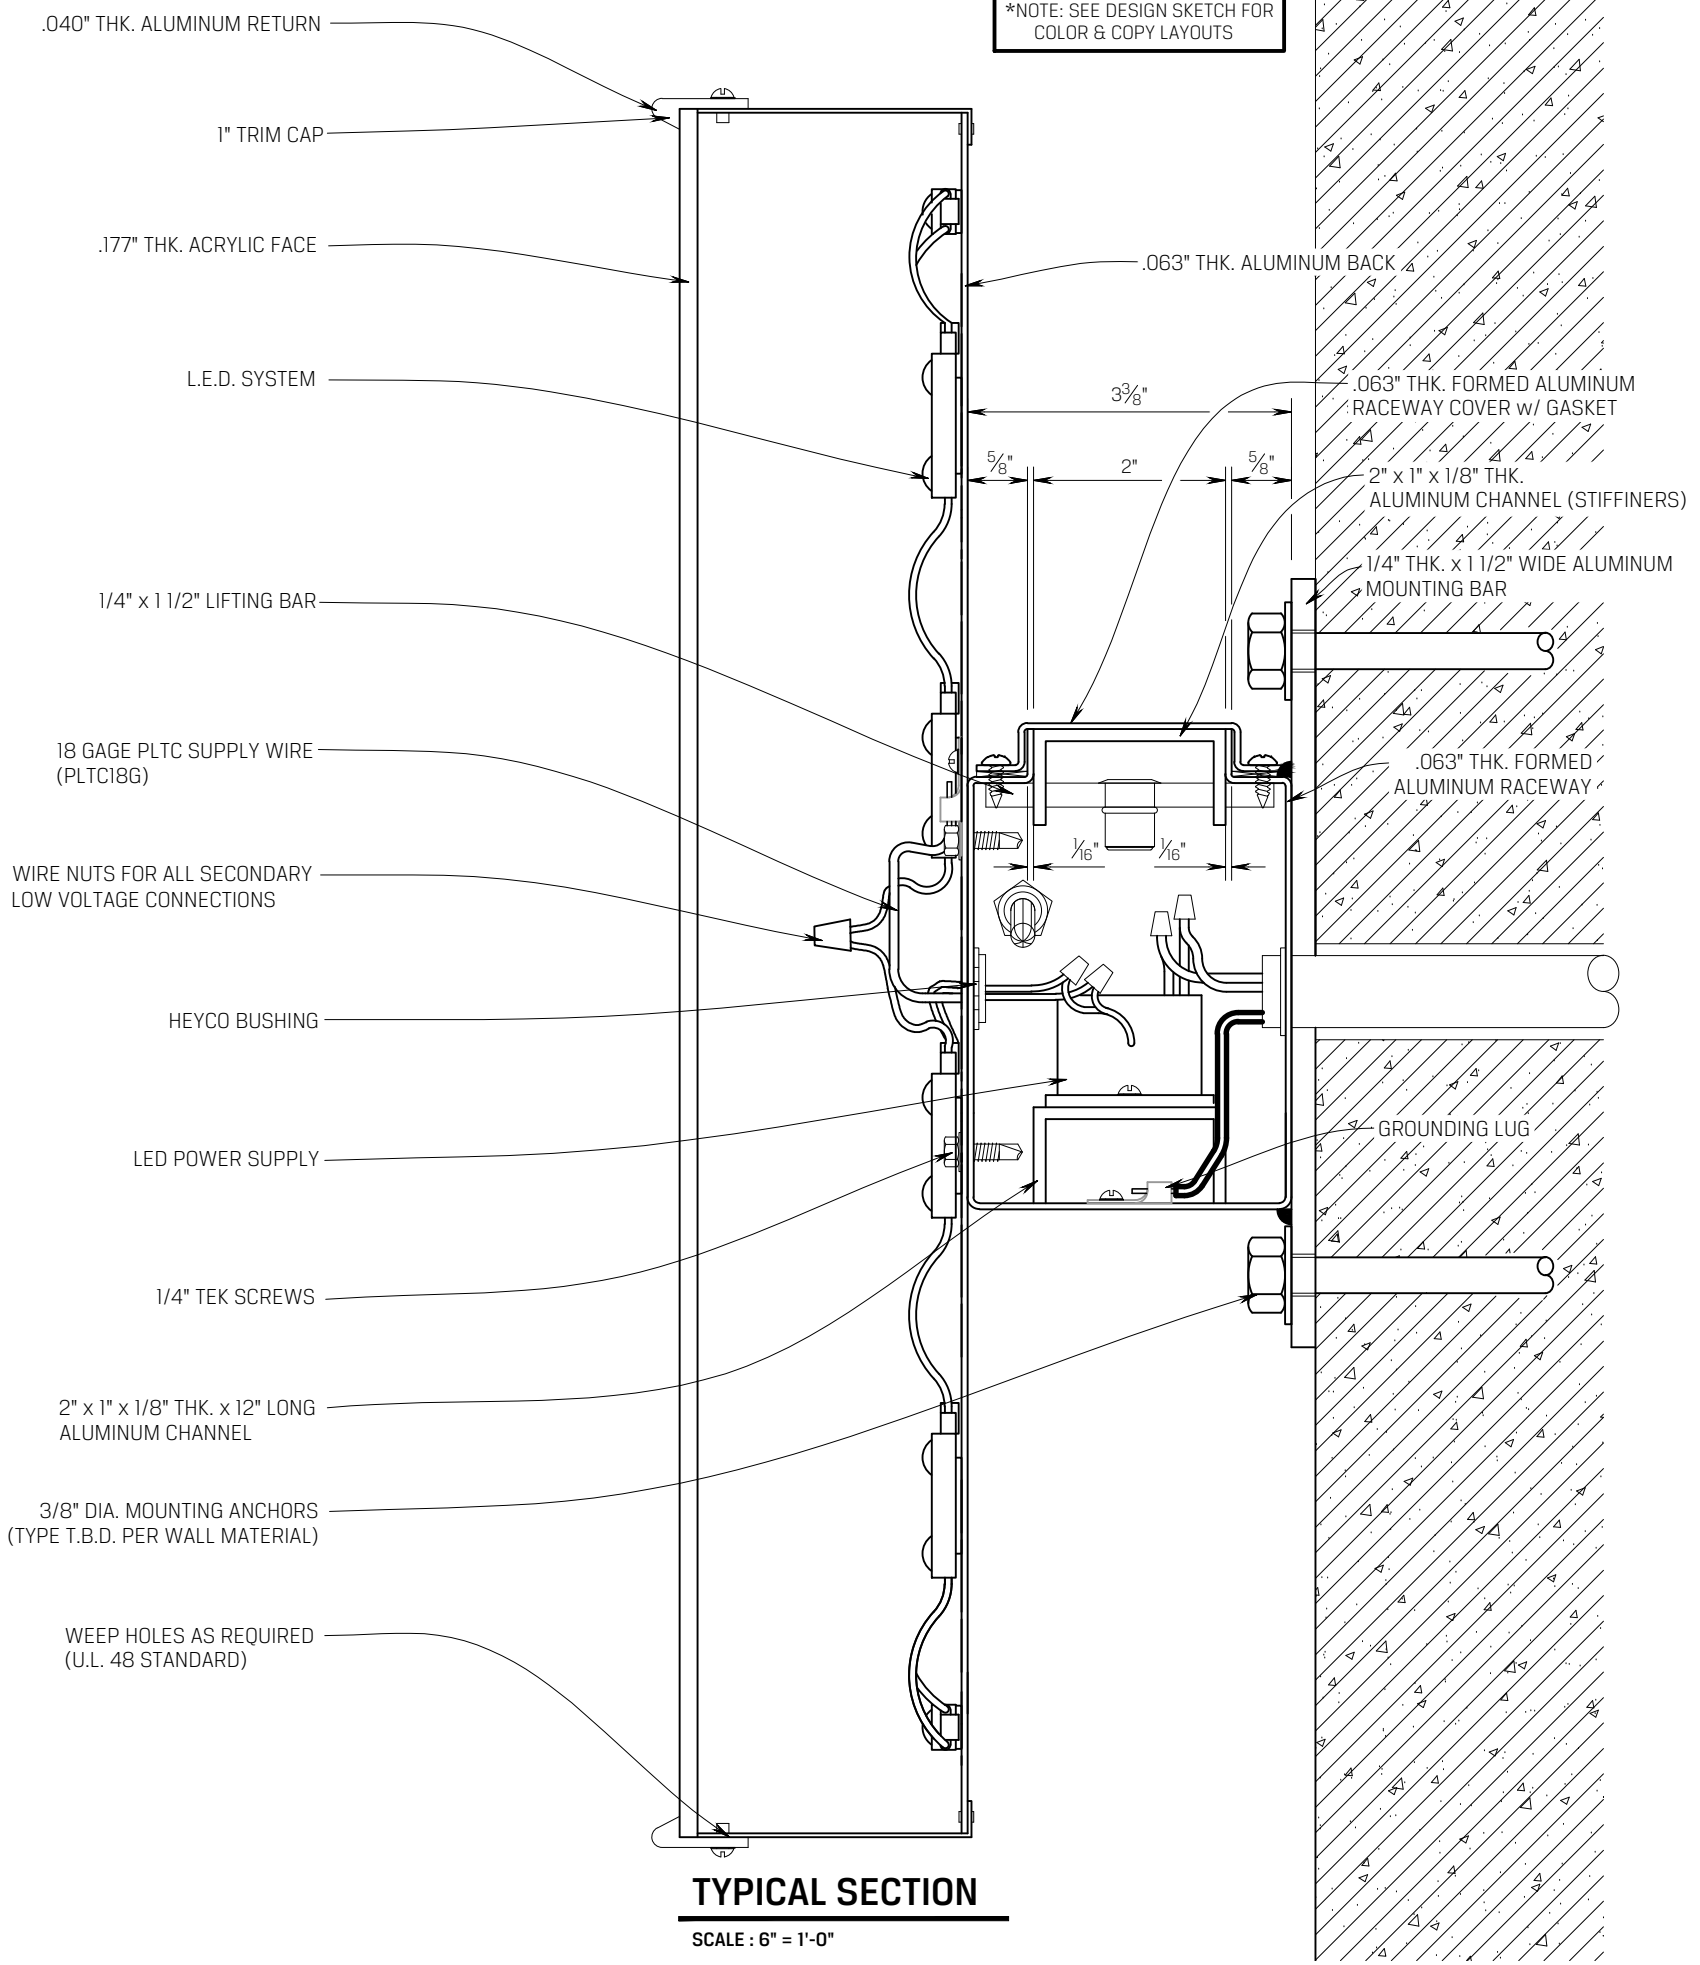


**TYPICAL SECTION**  
SCALE: 6" = 1'-0"

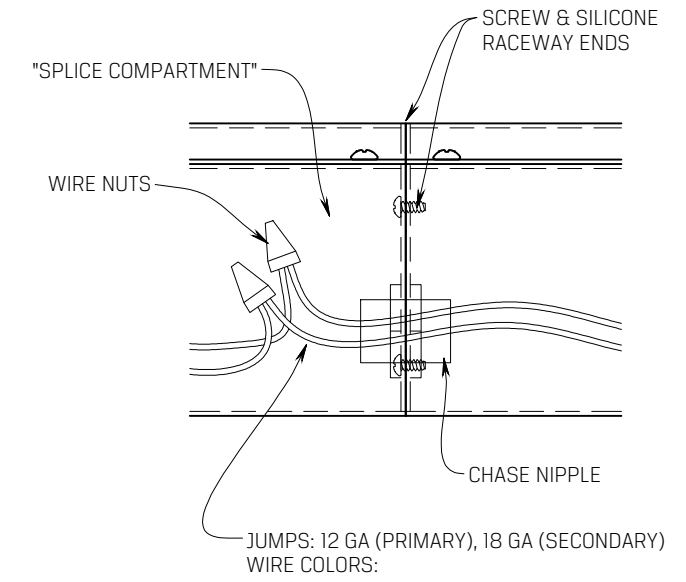

**"BUTTING" RACEWAY DETAIL**

NTS

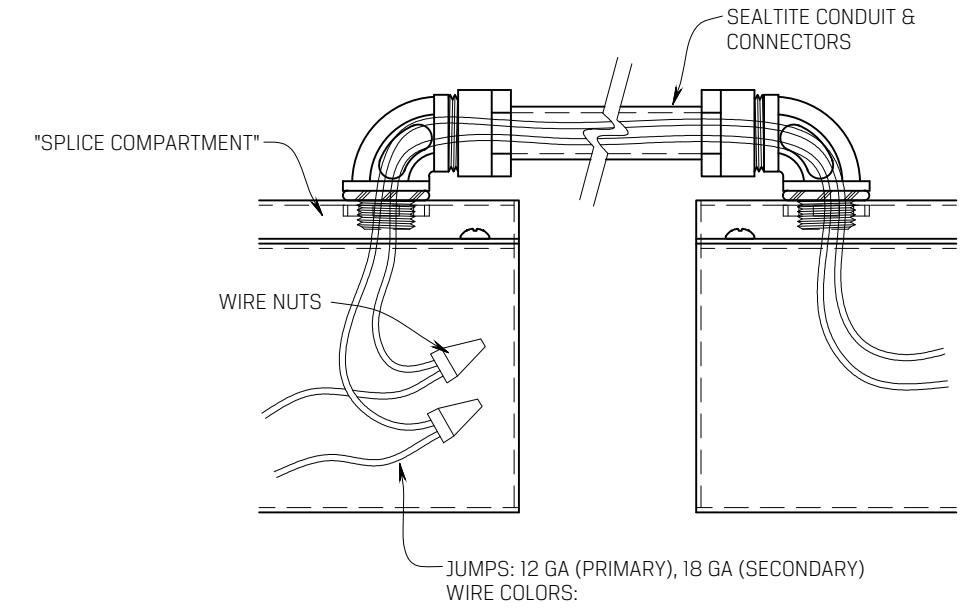

**"SEPARATED" RACEWAY DETAIL**

NTS

BOND & GROUND ACCORDING TO N.E.C. ARTICLE 600 & U.L. 48 STANDARDS  
PRIMARY ELECTRICAL SUPPLY & FINAL HOOK UP TO BE DONE BY LOCALLY LICENSED ELECTRICAL CONTRACTOR.  
**1.96 AMPS @ 120/277 VOLTS**

FILE: R:\Drawings\Aurora\MILWAUKEE\83135-LL-01.dwg SHEET: S01 PLOTTED: Oct 29, 2018 10:16 AM BY: Trapp, Ryan

# SIGN SPECIFICATIONS

## [A] - NON-ILLUMINATED LOGO

**Description:** FCO  
**Material:** Aluminum  
**Depth:** 3/16"  
**Color:** Painted to match Rust Brown 3630-63 vinyl with 7725-20 White vinyl graphics applied to 1st surface  
**Installation:** Stud mounted flush to ribbed CMU Wall - Longer studs required

## [B] - NON-ILLUMINATED LETTERS

**Description:** FCO  
**Material:** Aluminum  
**Depth:** 3/16"  
**Color:** White (satin)  
**Installation:** Stud mounted flush to ribbed CMU Wall - Longer studs required




Existing Layout




Proposed Layout

Non lit letters to replace existing 'Aurora Credit Union' letters facing parking area.

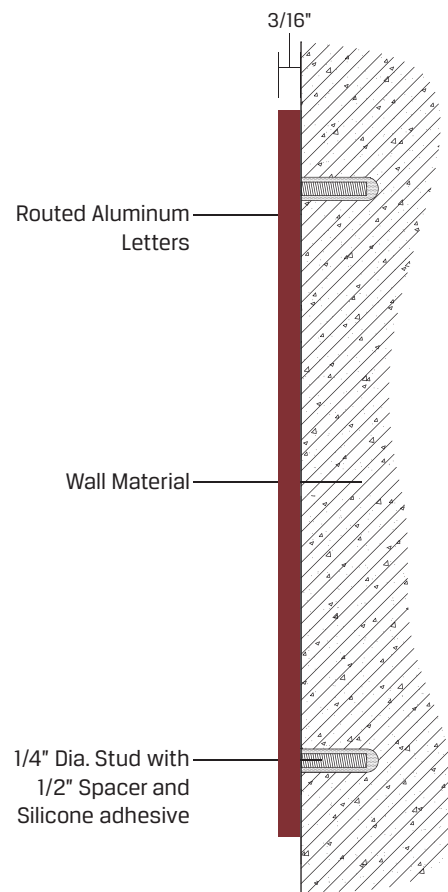

Side View

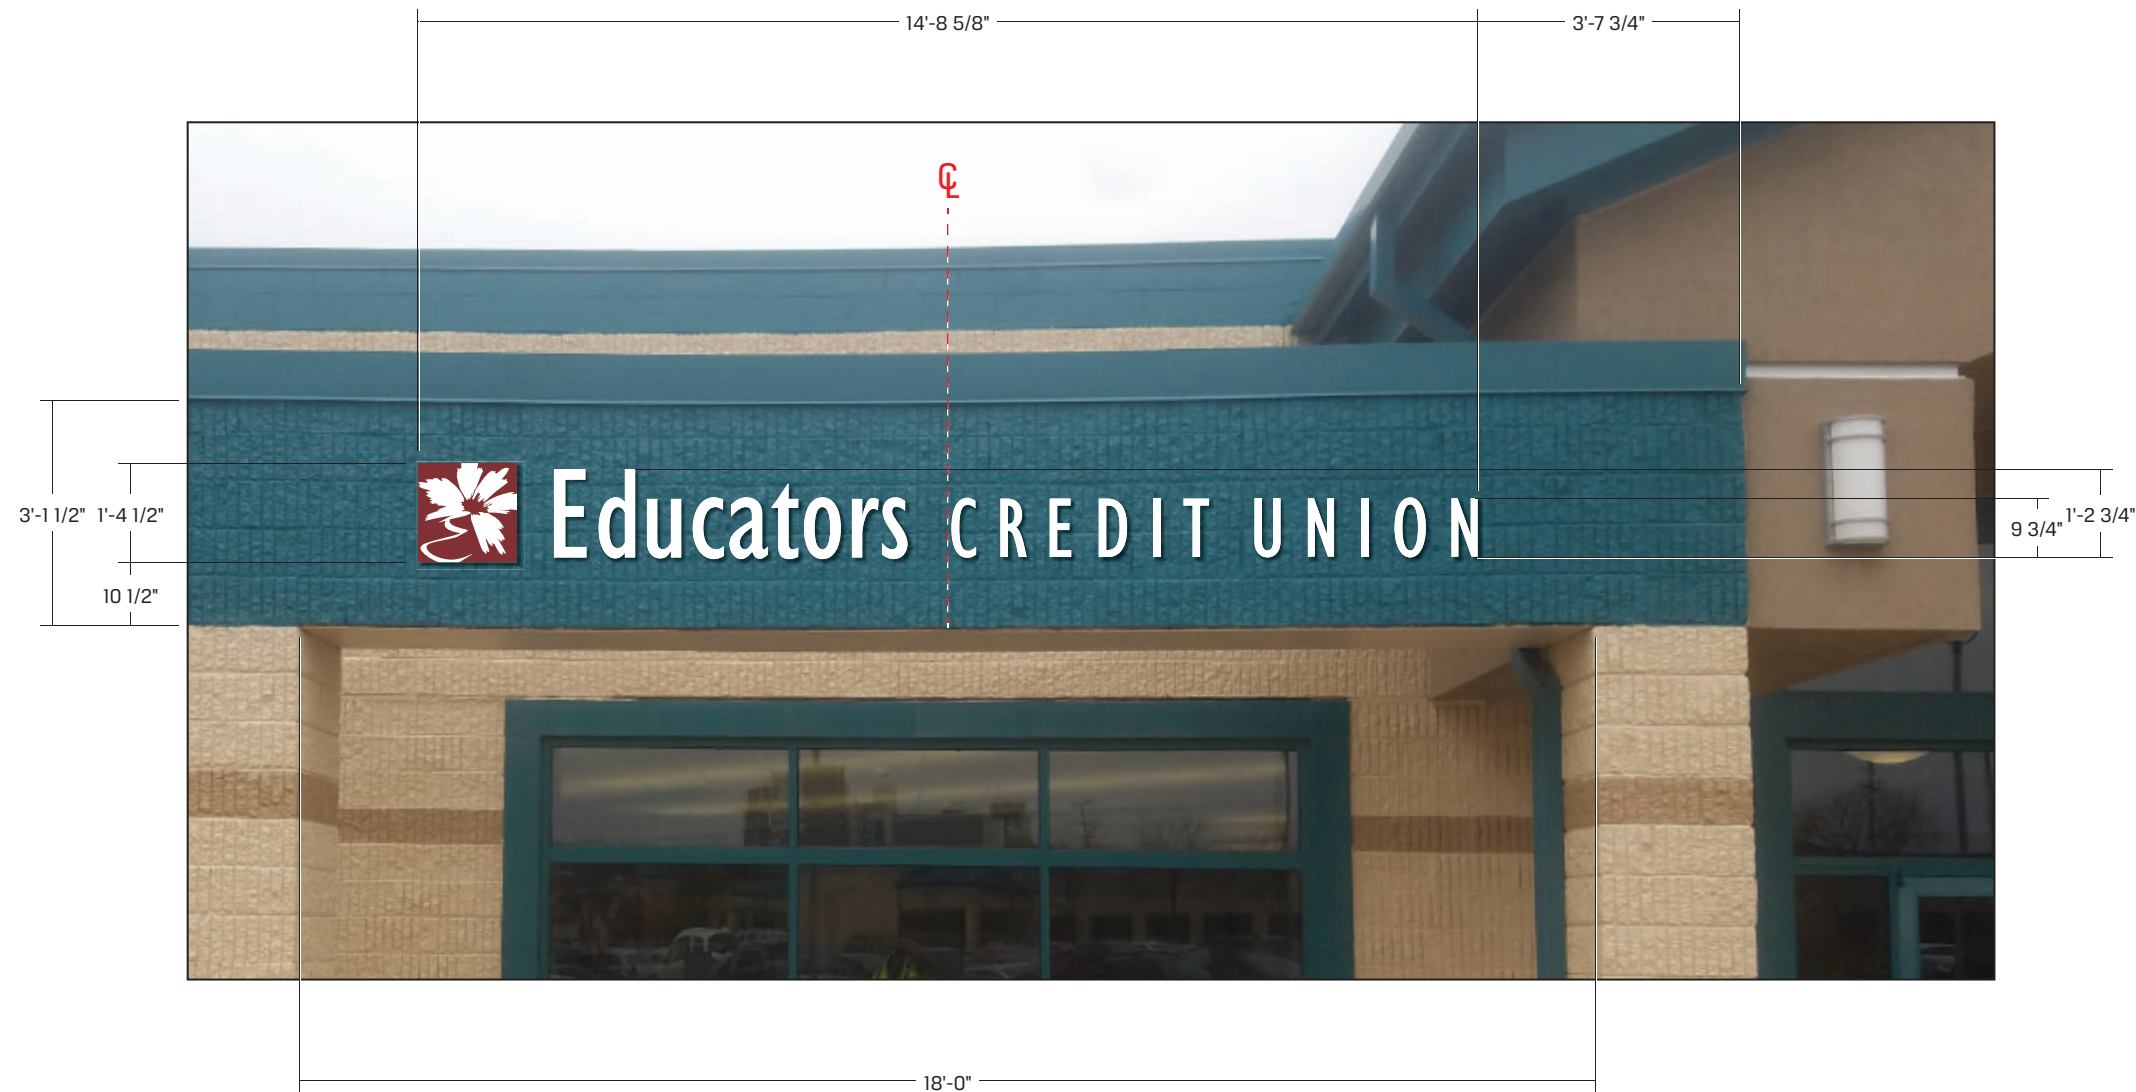

This document is owned by and the information contained in it is proprietary to Poblocki Sign Company, LLC. By receipt hereof, the holder agrees not to use the information, disclose it to any third party or reproduce this document without the prior written consent of Poblocki Sign Company, LLC. Holder also agrees to immediately return this document upon request by Poblocki Sign Company, LLC.

This document represents only an approximation of material colors specified. Actual product colors may vary from this print or digital image.

### Project

**Educators Credit Union**  
**Aurora Forest Home Business Center**  
 Milwaukee, Wisconsin

Scale: 3/8"=1'

Original Page Size: 11" x 17"

### Notes

Line 0005

### Revisions

REV	DESCRIPTION	BY	DATE
01	logo color added	sew	10.04.18
02	Pre-Prod Update	JJ	11/01/18
03	release	rl	11/21/18

Rep: Matt Kaminski

Drawn By: Sarah Watson Orig. Date: 08/21/18

Sign Loc. No. .

**NL-01**

Non-Lit Letters  
 Sign. Type

**83135**

OPP - Project - Job No.

**J01**

Design