


Alexian Village Health Care Center

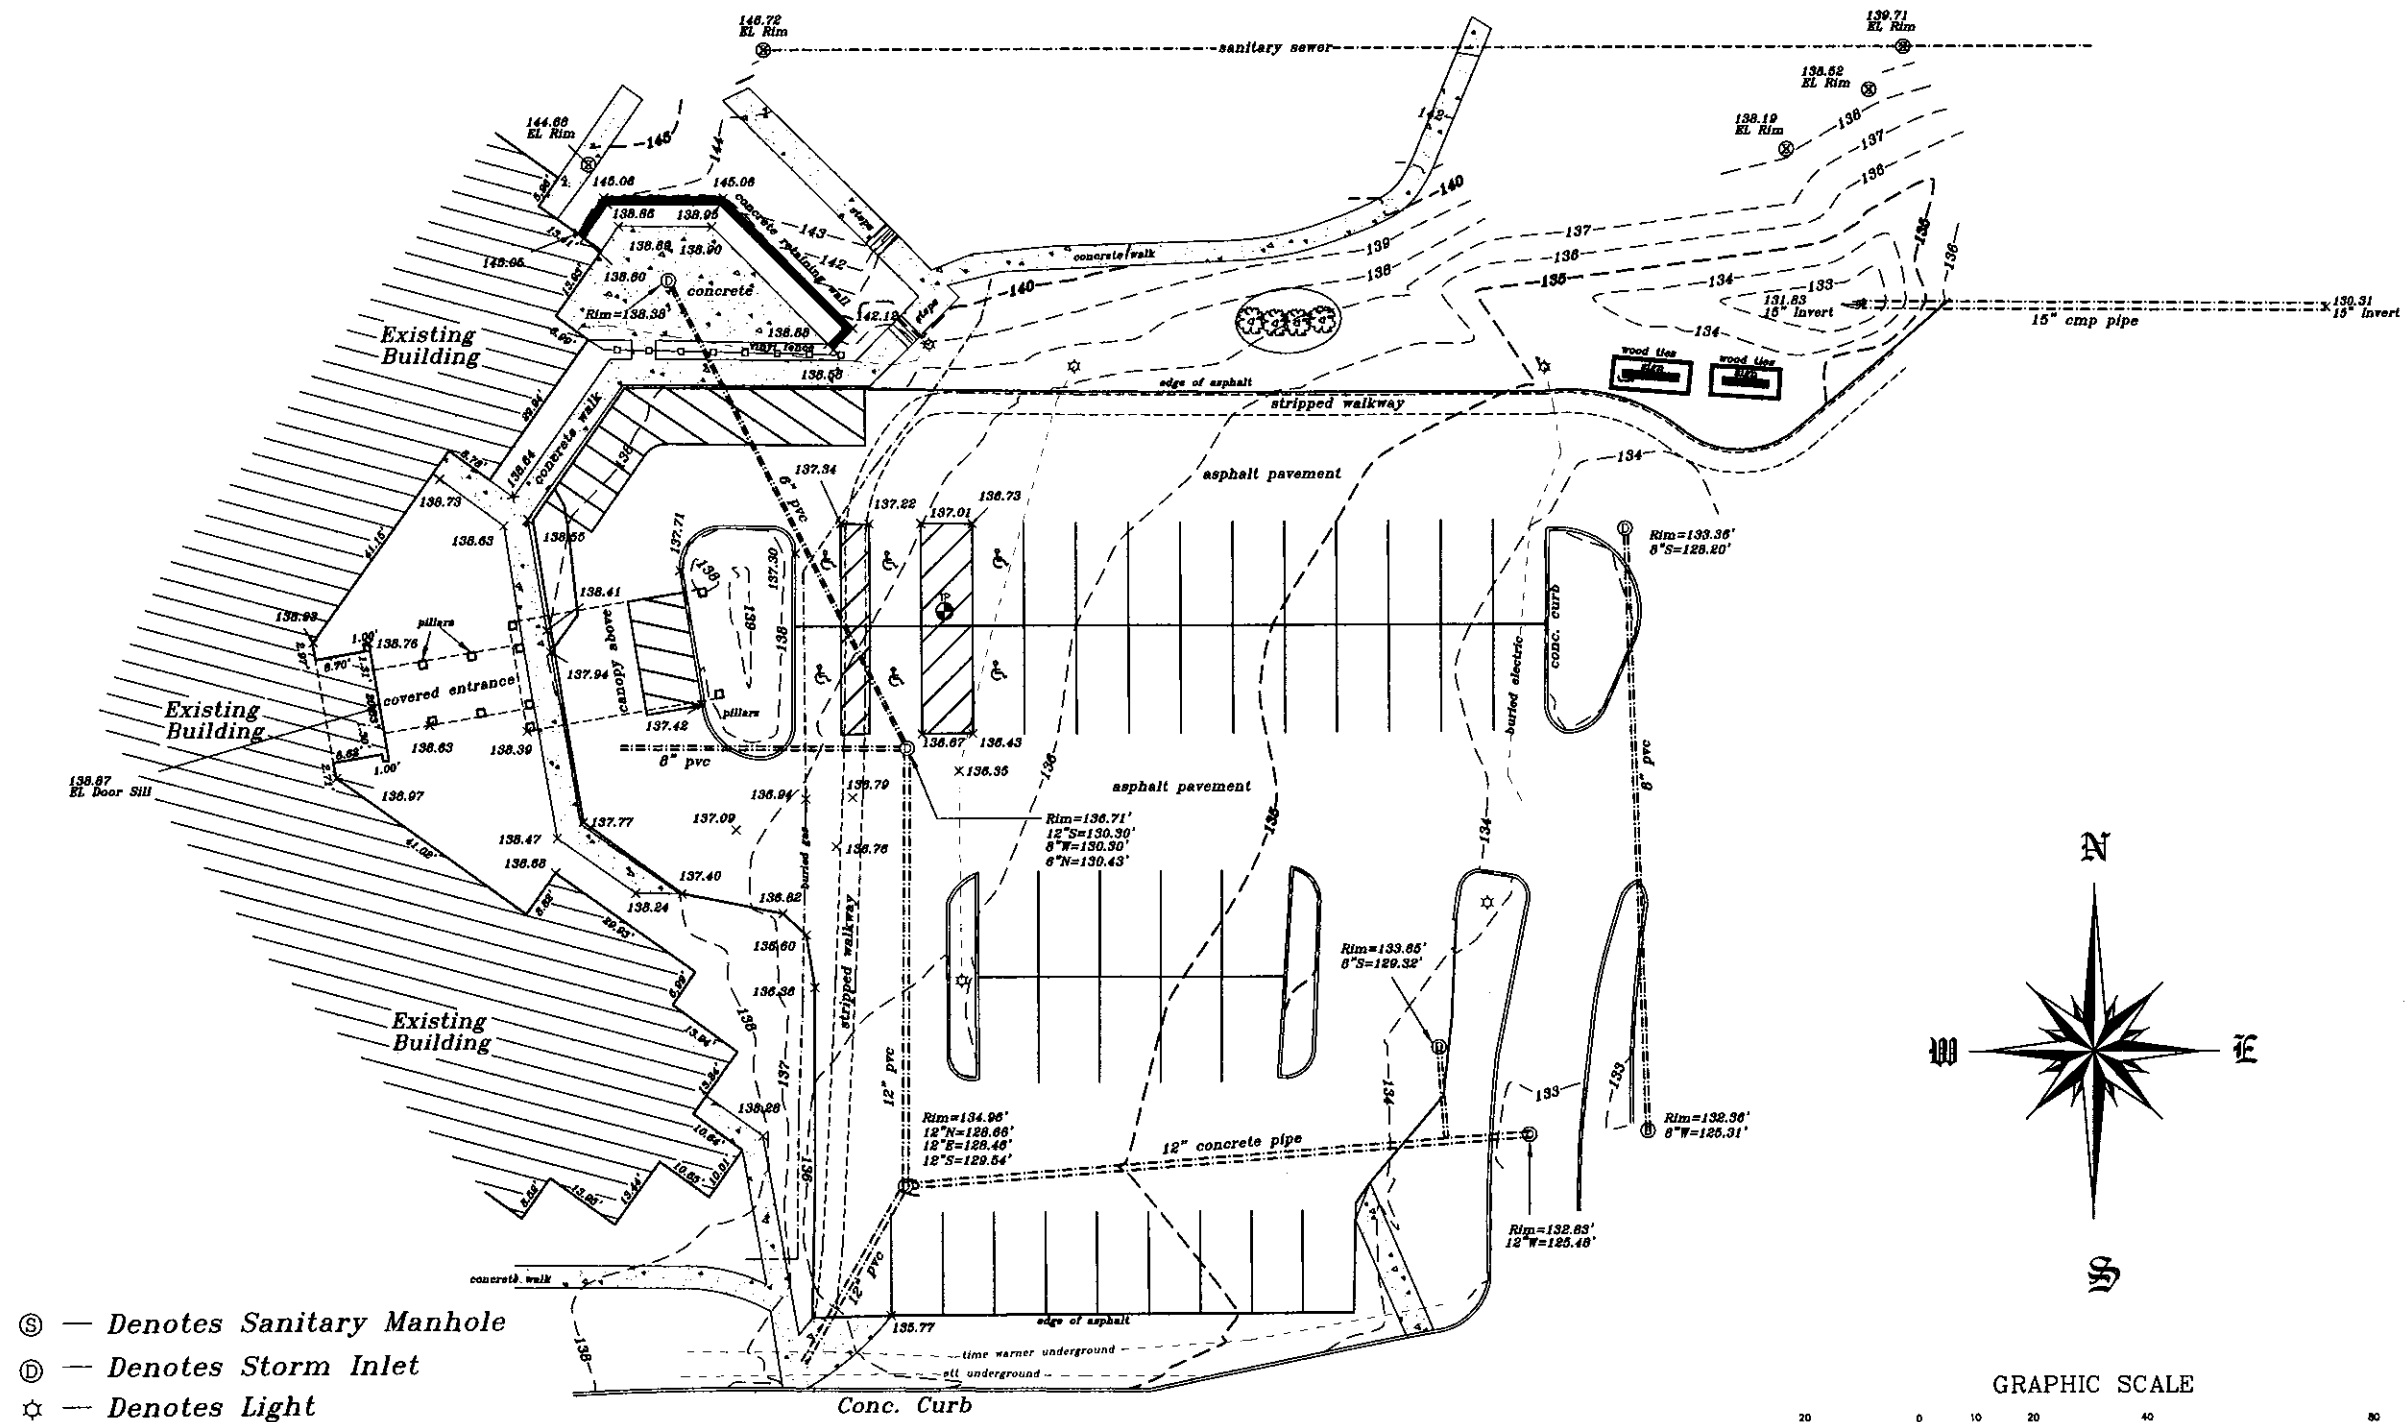

METROPOLITAN SURVEY SERVICE, INC.

REGISTERED LAND SURVEYORS AND CIVIL ENGINEERS
 5307 S. 92ND STREET, SUITE 140, HALES CORNERS, WI 53130
 PH. (414) 529-5380 FAX (414) 529-9787
 email address: survey@bizwi.rr.com

Service Road


S:\102838.dwg 11/17/2010 11:38:21 AM CST

Survey No. 102838



-

A101

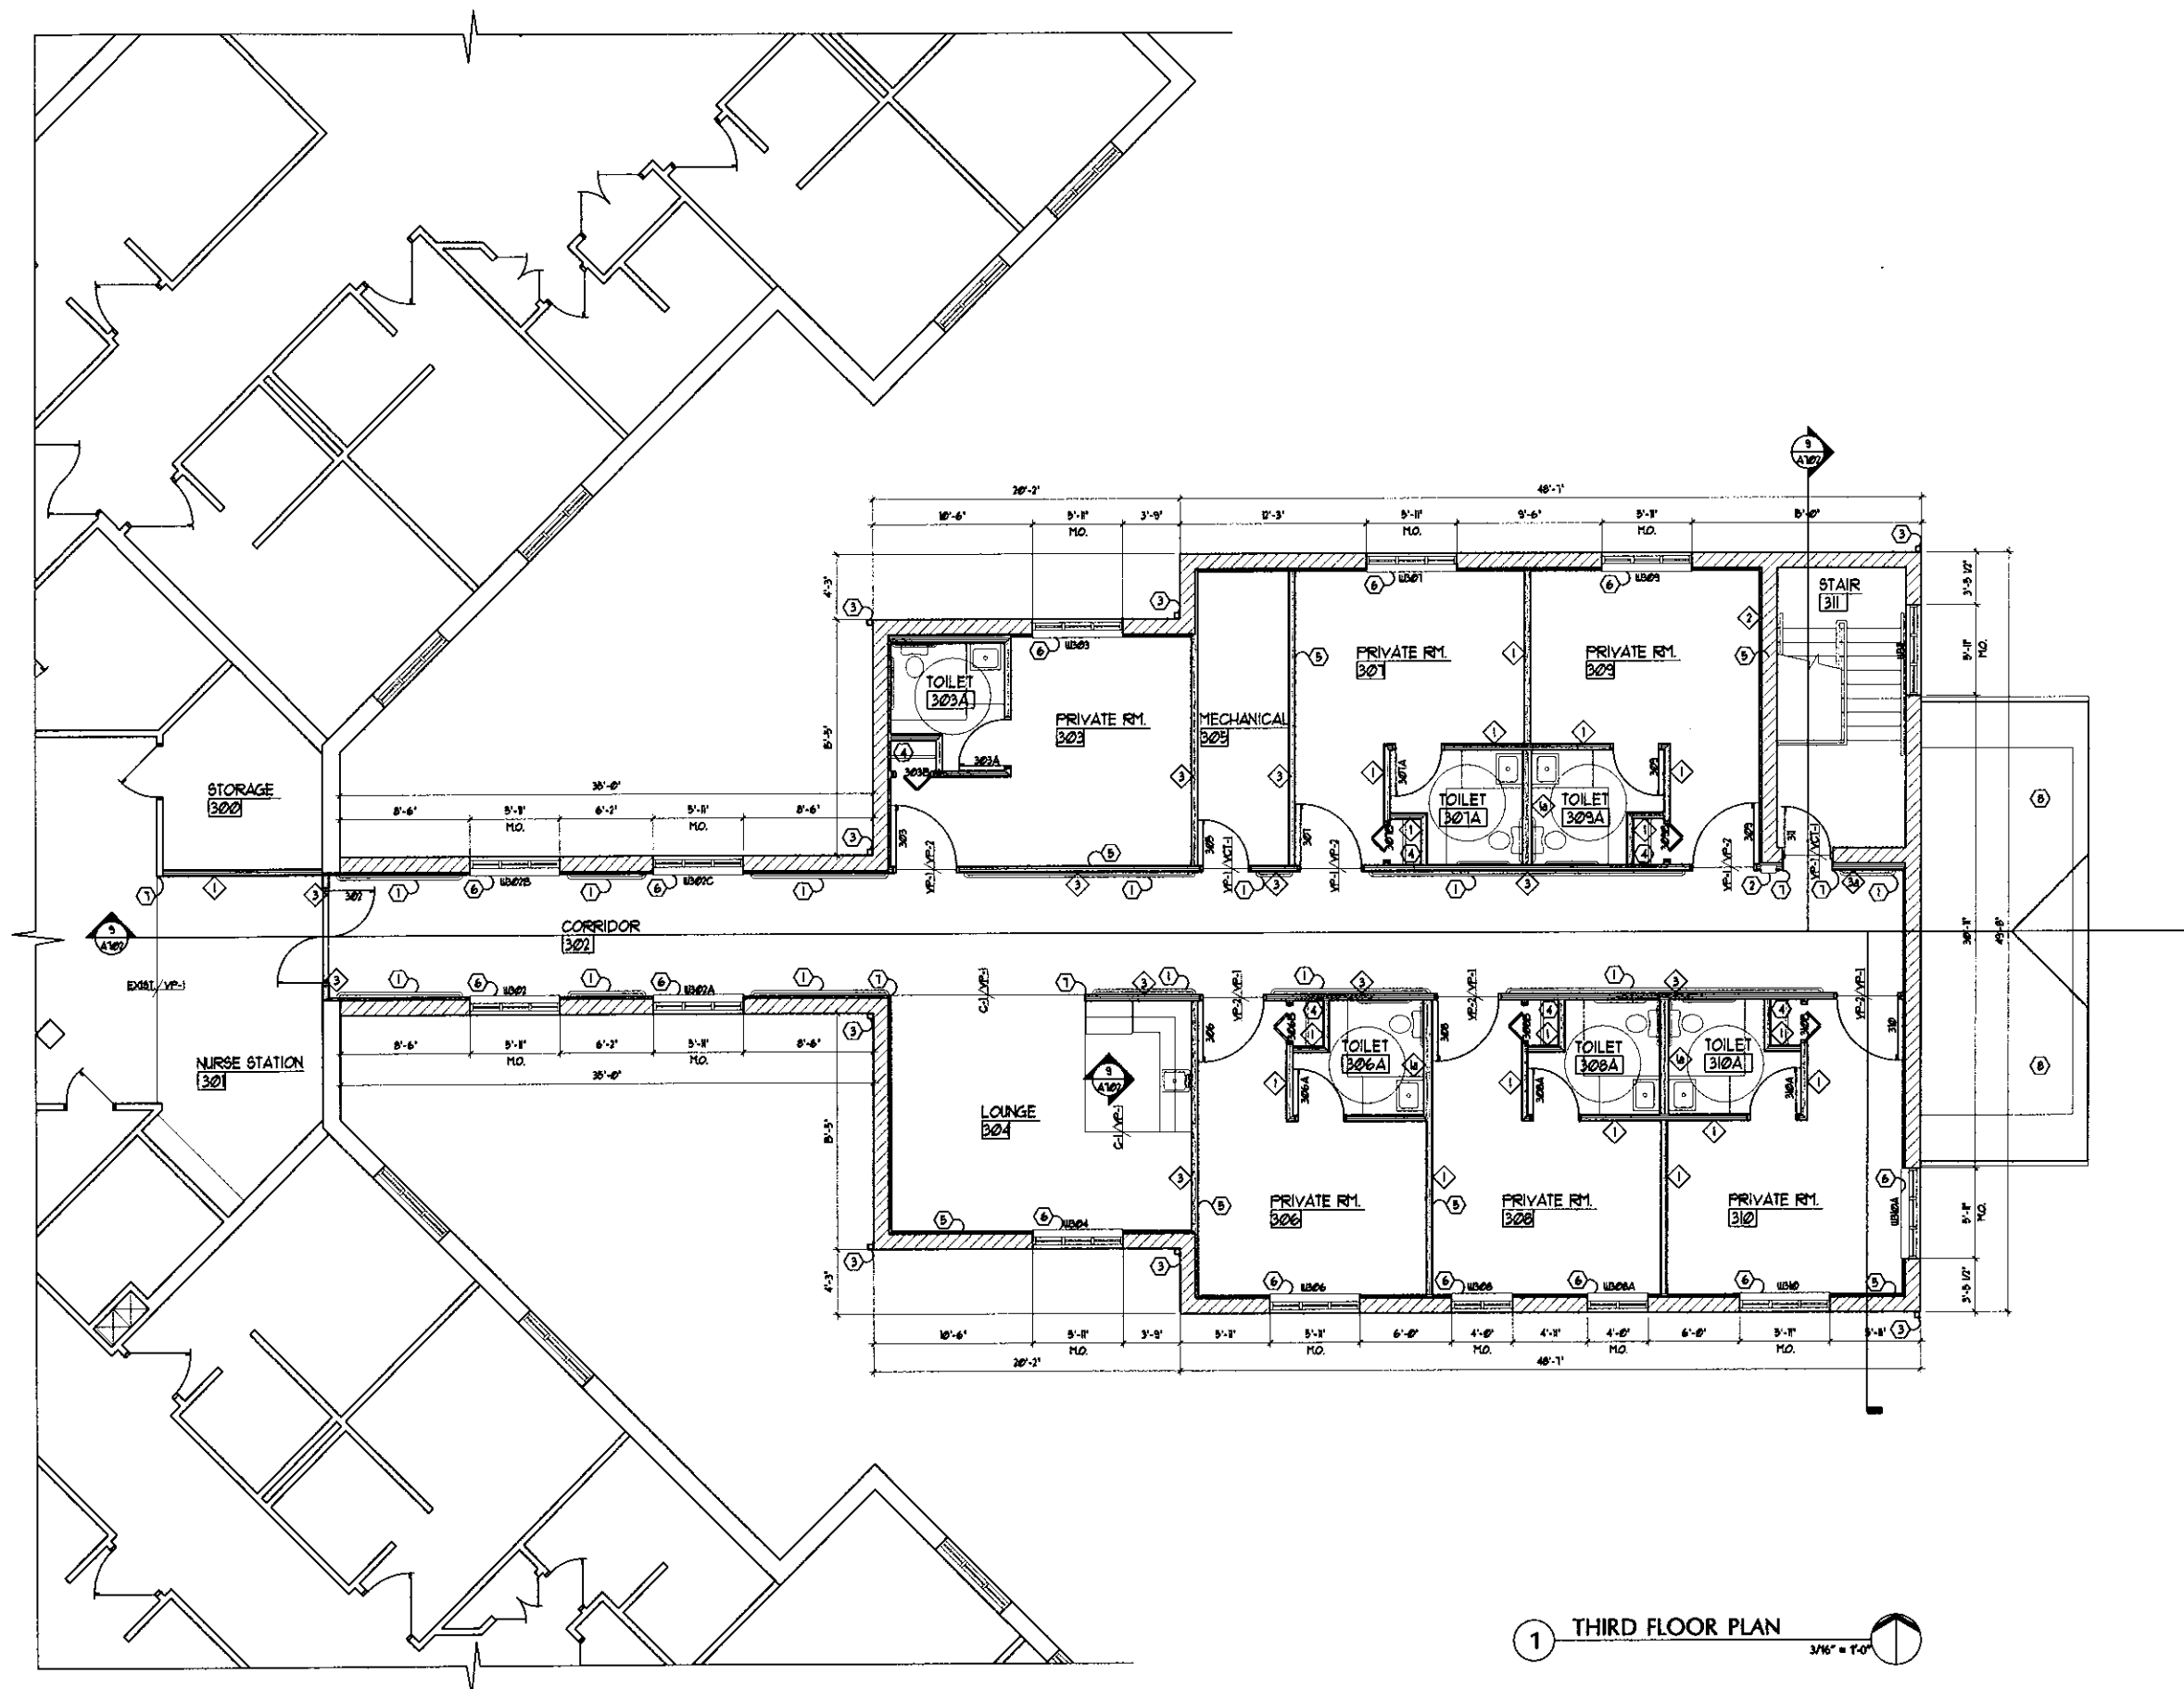

1 THIRD FLOOR PLAN
3/16" = 1'-0"

LEGEND

- NEW METAL STD PARTITION
- NEW CMU PARTITION
- EXISTING WALL TO REMAIN
- NEW DOOR
- EXISTING DOOR TO REMAIN
- WALL TYPE
- KEYED NOTE
- WINDOW DESIGNATION

WALL TYPES - THIS SHEET

- 1 PARTITION TYPE: (1) LAYER 5/8" GIBS BOTH SIDES OF 3-5/8" METAL STUDS @ 16" O.C. WITH 3-1/2" FIBERGLASS SOUND INSULATION BATT. EXTEND PARTITION TO UNDERSIDE OF STRUCTURE. NOTE: PROVIDE 5/8" MOISTURE RESISTANT GIBS AT PARTITION FACES WITHIN 6'-0" MIN. OF ALL PLUMBING FIXTURES.
- 2 PARTITION TYPE: SAME AS WALL TYPE 1, EXCEPT 6" METAL STUDS.
- 3 FIREWALL: (1) LAYER 5/8" GIBS ONE SIDE ATTACHED TO 2" CHANNELS @ 24" O.C. WITH 2" RIGID INSULATION ATTACHED TO 2" CONCRETE THRU BLOCK. 1-HOUR FIRE RATED ASSEMBLY PER UL318.
- 4 CORRIDOR WALL TYPE: (1) LAYER 5/8" TYPE-X GIBS BOTH SIDES OF 3-5/8" METAL STUDS @ 16" O.C. WITH 3-1/2" FIBERGLASS SOUND INSULATION BATT. EXTEND PARTITION TO UNDERSIDE OF STRUCTURE. NOTE: PROVIDE 5/8" MOISTURE RESISTANT TYPE-X GIBS AT PARTITION FACES WITHIN 6'-0" MIN. OF ALL PLUMBING FIXTURES. 1-HOUR FIRE RATED ASSEMBLY PER UL318.
- 5 CORRIDOR WALL TYPE: SAME AS ALL TYPE 3' EXCEPT ONLY ONE LAYER GIBS INTERIOR SIDE OF PARTITION. ALIGN FACE OF PARTITION WITH FACE OF CORRIDOR.

KEYED NOTES, THIS SHEET

- 1 SOLID WOOD HANDRAIL ATTACHED TO 1x6 WOOD TRIM. STAIN AND VARNISH FINISHED. MOUNT 1x6 TRIM AT 7'-1" AFF.
- 2 2x4 RECESSED FIRE EXTINGUISHER CABINET. MOUNT TOP OF CABINET AT 5'-0". HANTAN WALL FIRE-RATING AT RECESS.
- 3 PREFINISHED METAL DOWNSPOUT. FINAL SIZE AND LOCATION BY PLUMBING CONTRACTOR.
- 4 CLOSET SHELF AND POLE, MOUNTED AT 5'-4" AFF. SEE DRAWING 4100A.
- 5 PROVIDE SOLID WOOD BLOCKING, ELECTRICAL AND CABLE FOR FLAT SCREEN TELEVISION INSTALLATION.
- 6 FINISH AND INSTALL CORIAN WINDOW SILL. SEE SHEET 400A FOR CORIAN COLOR SELECTION.
- 7 1"x1" CORNER GUARDS. MATCH EXISTING.
- 8 ROOF BELOW SEE SHEET 400A.



Erik L. Madisen, AIA

**MADISEN
ARCHITECTS**

828 N. Broadway, Suite 206
Milwaukee, WI 53202
t (414) 277-8000
f (414) 283-9569
madisenarchitects.com

project title:

AN ASSISTED LIVING
ADDITION FOR:

**ALEXIAN VILLAGE
HEALTH CARE
CENTER**

9255 N. 76TH STREET
MILWAUKEE, WI 53223

sheet title:

**THIRD FLOOR
PLAN**

revisions:

date:
10/21/2010

drawn by:
KAK

file name:
line1

line 2

project number:
2009.041

scale:
3/16" = 1'-0"

sheet number:

A103



Erik L. Madisen, AIA

**MADISEN
ARCHITECTS**

828 N. Broadway, Suite 206
Milwaukee, WI 53202
t (414) 277-8000
f (414) 283-9569
madisenarchitects.com

project title:

AN ASSISTED LIVING
ADDITION FOR:

**ALEXIAN VILLAGE
HEALTH CARE
CENTER**

9255 N. 76TH STREET
MILWAUKEE, WI 53223

sheet title:

**PROPOSED
ELEVATIONS**

revisions:


date:
10/24/2010
drawn by:
KAK

file name:
line1
line 2
project number:
2009.041


scale:
1/8"=1'-0"

sheet number:

A401

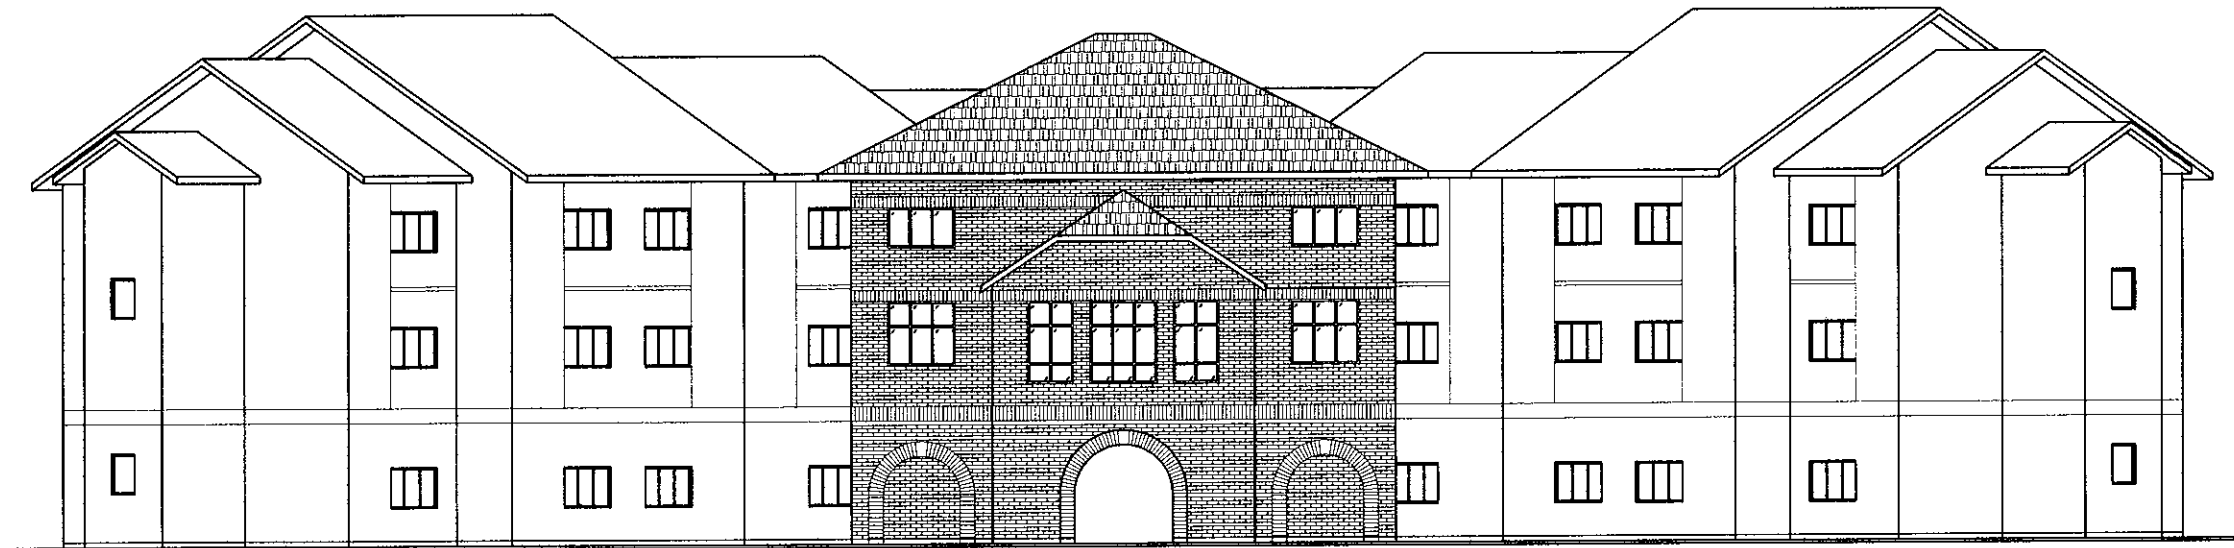

1 PROPOSED ELEVATION
1/8" = 1'-0"

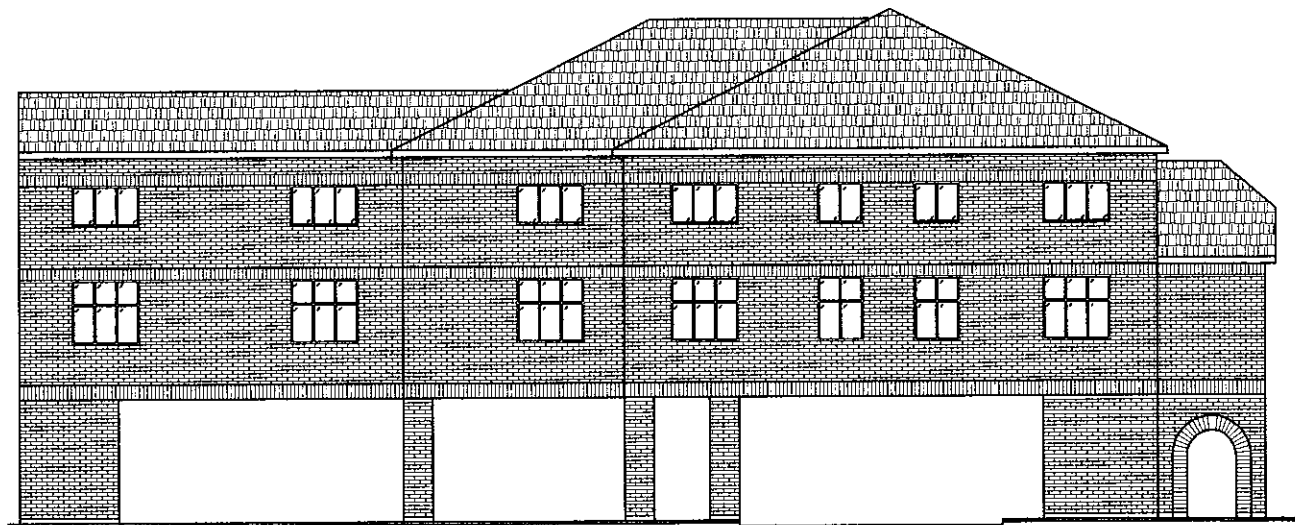

2 PROPOSED ELEVATION
1/8" = 1'-0"