




**DEEP
RIVER
PARTNERS**

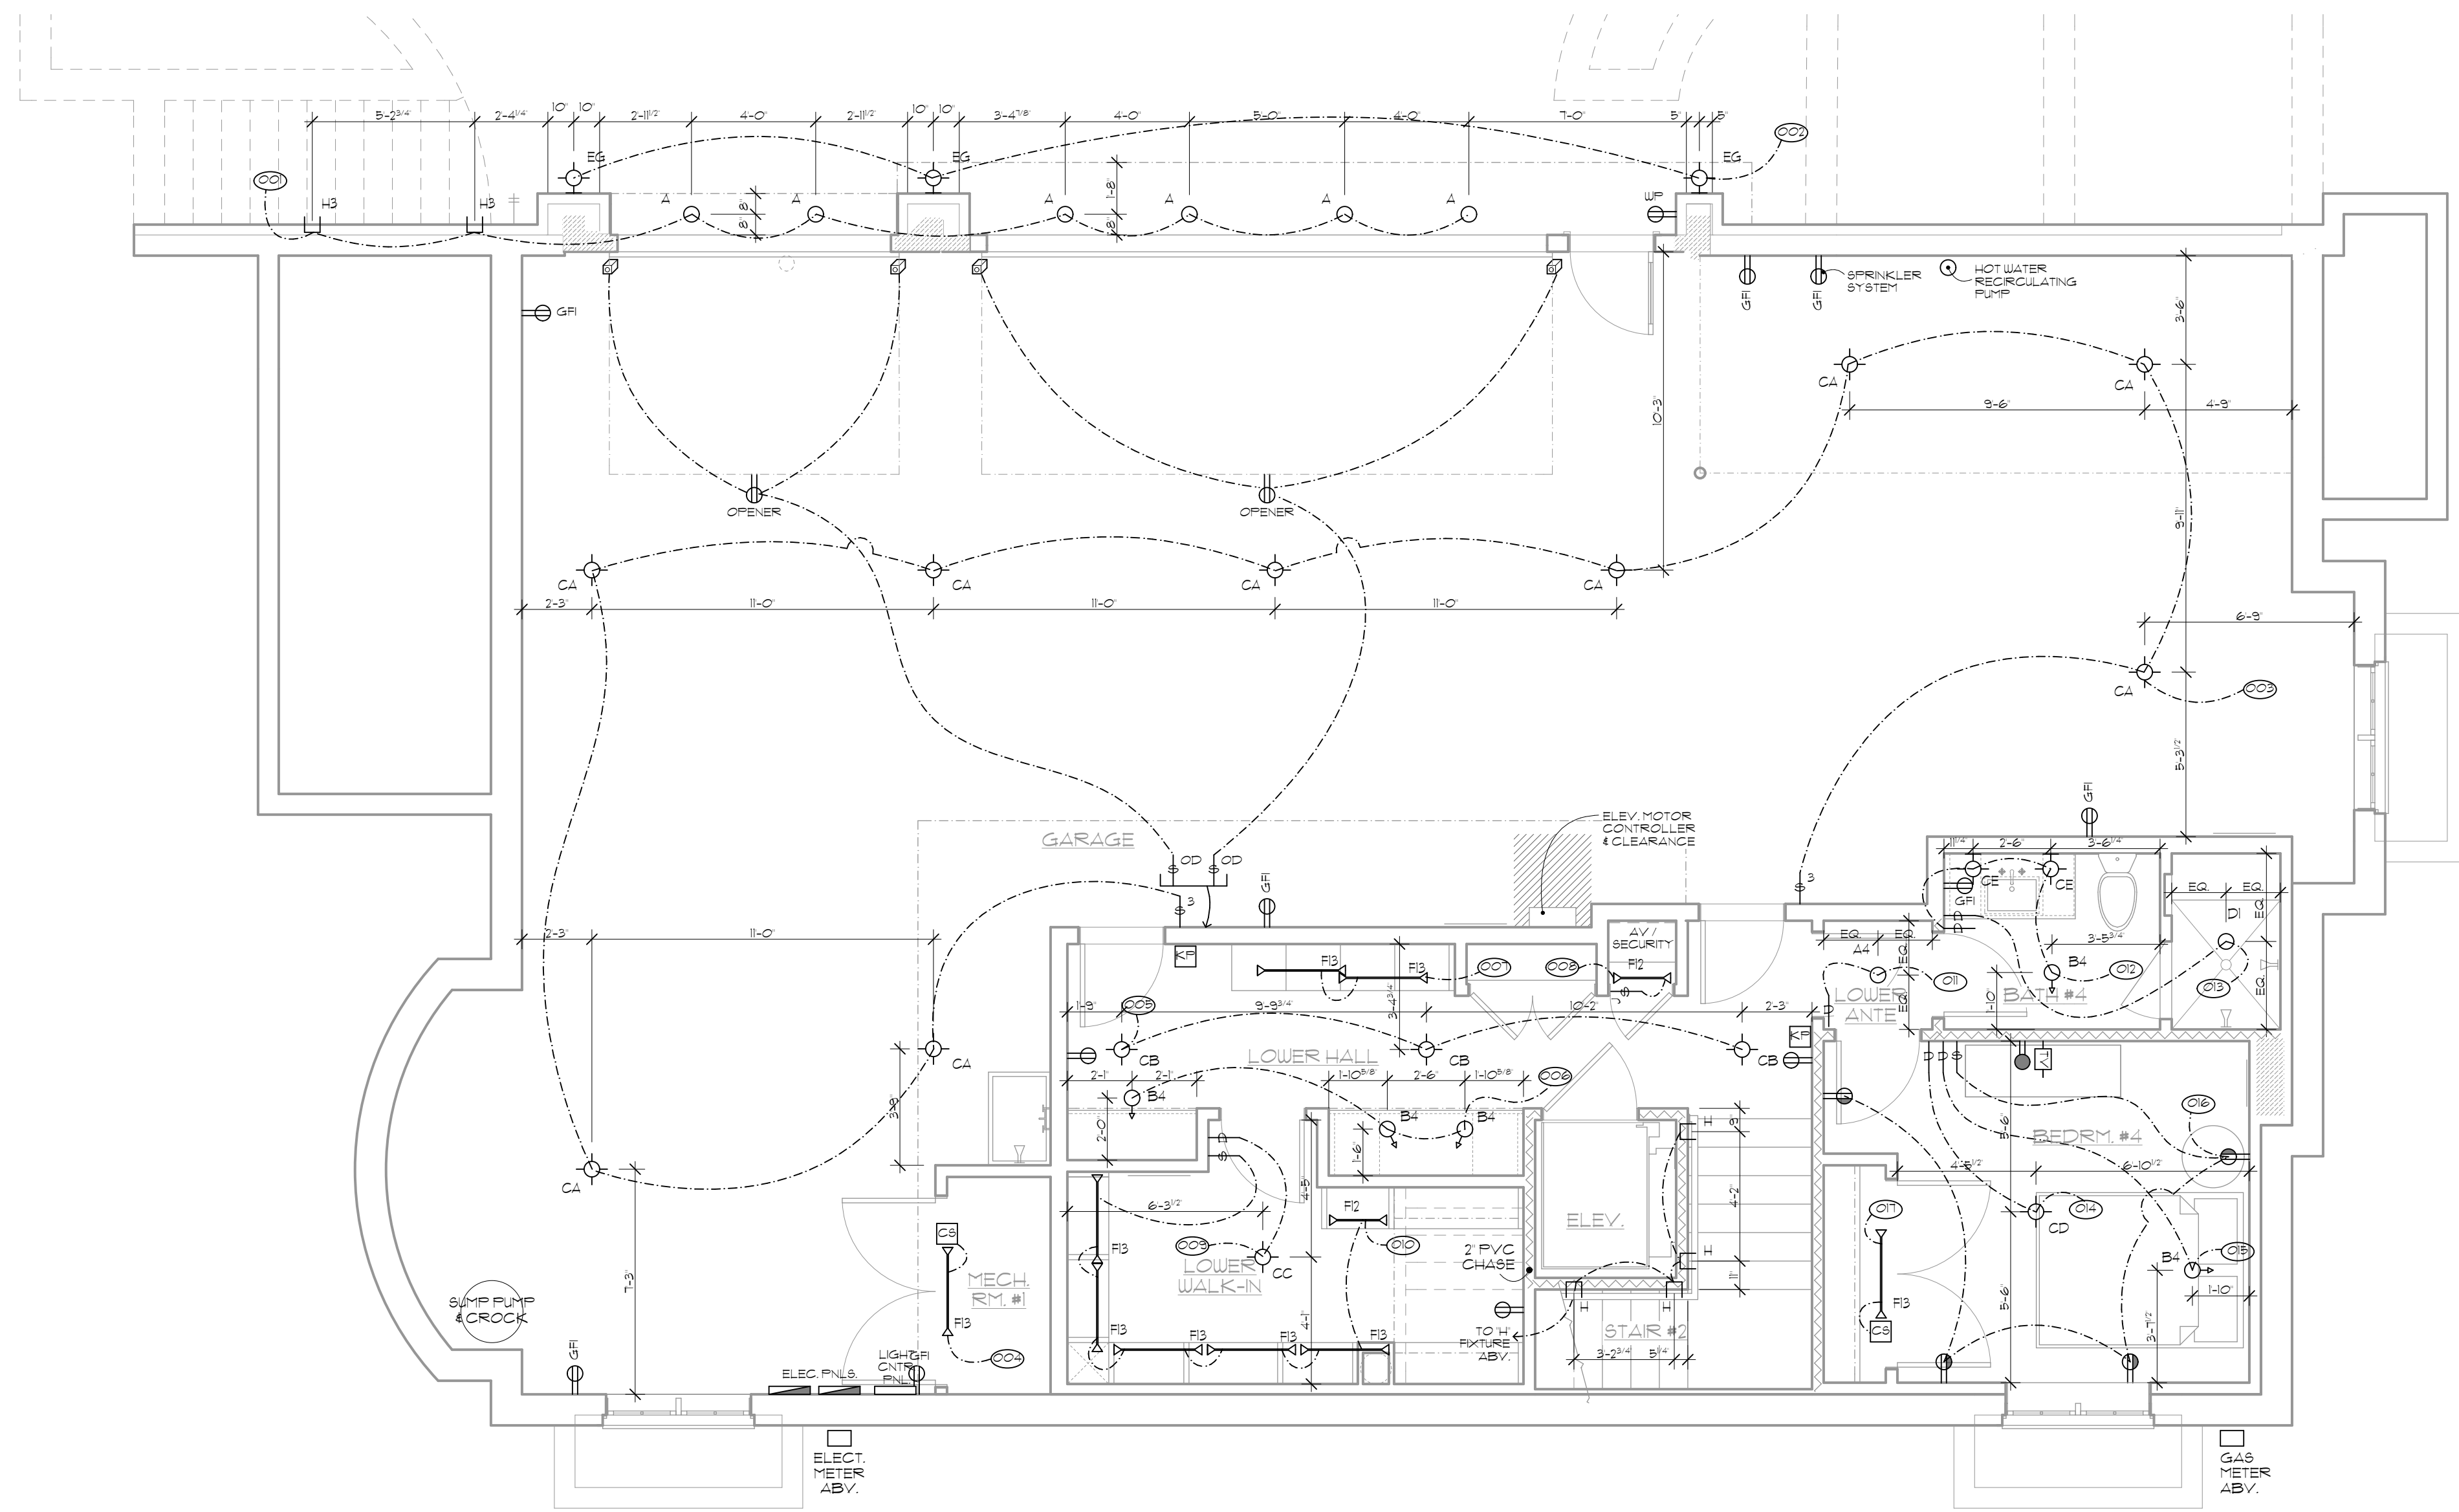

1 LOWER LEVEL ELECTRICAL PLAN
SCALE: 1/4" = 1'-0"

ELECTRICAL KEY			
	LIGHT FIXTURE		CIRCUITRY
	CEILING MOUNTED EXHAUST FAN		SINGLE POLE SWITCH
	CEILING MOUNTED EXHAUST FAN + LIGHT		THREE WAY SWITCH
	WALL MOUNTED EXHAUST FAN		FOUR WAY SWITCH
	TRACK LIGHT		DOOR JAMB SWITCH
	RECESSED DOWNLIGHT		DIMMER SWITCH
	FIBER OPTIC END EMITTER		DIMMER SWITCH THREE WAY
	WALL WASH (grading indicates lighted face)		DIMMER SWITCH FOUR WAY
	RECESSED INFLOOR UPLIGHT		LIGHT CONTROL PANEL
	ADJUSTABLE ACCENT RECESSED FIXTURE		MAIN POWER DISTRIBUTION PANEL
	CEILING MOUNTED LIGHT		COMBINED LIGHT CONTROL PANEL / CIRCUIT SUBPANEL
	SURFACE MOUNTED GROUND LIGHT		MASTER MULTI-ZONE CONTROL
	WALL MOUNTED LIGHT		REMOTE MULTI-ZONE CONTROL
	WALL MOUNTED ADJUSTABLE ACCENT LIGHT		REMOTE MULTI-ZONE CONTROL
	VERTICAL STRIP LIGHT		LIGHT LOAD TO BE CARRIED BY PANEL # SWITCH IS NOT INDICATED
	LED TASK LIGHT		SINGLE RECEPTACLE
	TABLE LAMP		DUPLEX RECEPTACLE
	FIXED LENGTH LINEAR		WEATHER RATED DUPLEX RECEPTACLE GFI PROTECTED WEATHERPROOF BOX and/or BEZEL
	LOW OUTPUT LINEAR STRIP LIGHT		GFI DUPLEX RECEPTACLE GFI PROTECTED
	HIGH OUTPUT LINEAR STRIP LIGHT		220V RECEPTACLE
	SURFACE MOUNT TRACK LIGHT		DUPLEX RECEPTACLE SWITCHED
	IN WALL FIXTURE		DUPLEX OUTLET FLOOR MOUNT
	LIGHT SECURITY TYPE		DUPLEX OUTLET DISTRIBUTION PANEL
	FLUORESCENT ENCLOSED LIGHT		DUPLEX RECEPTABLES PAIRED ONE BOX
	PADDLE FAN / LIGHT		ISOLATED GROUND HOME RUN TO PANEL SAME PHASE AS PANEL
			UNDER CABINET RECEPTACLE STRIP
			EXISTING LOCATION NEW FIXTURE OR DEVICE
			LOW VOLTAGE THERMOSTAT
			SMOKE DETECTOR
			TELEVISION JACK BY LOW VOLTAGE CONTRACTOR
			DATA COMMUNICATIONS
			TELEPHONE OUTLET
			TELEPHONE OUTLET IN FLOOR
			DATA COMMUNICATIONS IN FLOOR
			OVERHEAD DOOR SWITCH
			OVERHEAD DOOR SENSOR
			DOOR BELL BUTTON
			DOOR CHIME
			CONTACT CLOSURE SWITCH BY LOW VOLTAGE CONTRACTOR
			KEYPAD LIGHT CONTROL BY LOW VOLTAGE CONTRACTOR
			WALL TOUCH SCREEN BY LOW VOLTAGE CONTRACTOR
			REMOTE TRANSFORMER
			REMOTE ILLUMINATOR
			REMOTE POWER SOURCE
			CONTROLLER

NOTES:
 1. SEE MECHANICAL SHEETS FOR EQUIPMENT POWER REQUIREMENTS.
 2. SEE ARCHITECTURAL SHEETS FOR ELECTRICAL INTEGRATION AT CASEWORK AND LIGHT COVES.
 3. SEE ELECTRICAL SCHEDULE FOR FIXTURE WALL MOUNT HEIGHTS.
 4. SINGLE LETTER DESIGNATIONS INDICATE RECESSED HOUSING FIXTURES AND SPECIAL EFFECT FIXTURES. DOUBLE LETTER DESIGNATIONS INDICATE SURFACE MOUNTED DECORATIVE FIXTURES.
 5. SEE APPLIANCE AND PLUMBING SCHEDULES FOR POWER REQUIREMENTS.
 6. & A.F.F. NOTATIONS DIMENSIONS ARE TO CENTERLINE OF J-BOX UNLESS NOTED OTHERWISE.
 7. ELECTRICAL KEY SYMBOLS ARE GENERAL LOCATIONS TO LOCATE POWER SUPPLIES & REMOTE TRANSFORMERS FOR LIGHT FIXTURES THAT REQUIRE THEM.

NOTE


ALTHOUGH EVERY EFFORT HAS BEEN MADE IN PREPARING THESE CONTRACT DOCUMENTS AND CHECKING THEM FOR ACCURACY, THE CONTRACTORS MUST CHECK ALL DETAILS AND DIMENSIONS AND BE RESPONSIBLE FOR SAME. THE CONTRACTORS SHALL BE RESPONSIBLE FOR MAKING SURE THAT ALL WORK IS DONE IN ACCORDANCE WITH ALL STATE AND LOCAL CODES. THE CONTRACT DOCUMENTS UTILIZE A PROCESS CALLED FREE DESIGN OR DESIGN/BUILD FOR ROOF WINDOW PLUMBING ELECTRICAL HVAC DETAILS AND AS DESIGNATED IN THE SPECIFICATION AS TO BE COMPLETED ON A DESIGN/BUILD BASIS. THIS MEANS THAT THE CONTRACT DOCUMENTS DO NOT INCLUDE ALL REQUIRED DETAILS AND THAT THE CONTRACTORS SHALL USE THEIR OWN STAFF OR QUALIFIED SUBCONTRACTORS DESIGN AND BUILD THE FREE DESIGN AND DESIGN/BUILD PORTIONS OF THE WORK. THE CLIENT IS DIRECTLY CONTRACTING WITH THE CONTRACTORS AND THEREFORE THE CLIENT AND THE CONTRACTORS ARE ASSUMING THE DESIGN AND BUILD RESPONSIBILITY FOR THE FREE DESIGN AND DESIGN/BUILD PORTIONS OF THE PROJECT. DEEP RIVER PARTNERS LTD IS NOT RESPONSIBLE FOR INSPECTING ANY ASPECT OF THE CONTRACTORS WORK OR FOR OBSERVATION OF THE CONTRACTORS WORK FOR COMPLIANCE WITH THE CONTRACT DOCUMENTS.

DEEP RIVER PARTNERS, LTD.
 338 N. MILWAUKEE STREET
 SUITE #505
 MILWAUKEE, WI 53202
 TELL 414-276-8550
 FAX 414-276-8560

Description	Date
REDLINE ISSUE	3/17/2016
1/4" OWNER APPROVAL	7/16/2015
HISTORICAL SUBMITTAL	5/5/2016
INTERIOR ELEVATIONS	12/17/2015
A/V ELEVATION ISSUE	
BID ISSUE	
PERMIT ISSUE	
CONSTRUCTION ISSUE	
ARCHITECTURAL REVIEW	

**1501
LAFAYETTE TOWN HOME
2115 E. LAFAYETTE PLACE
MILWAUKEE, WISCONSIN
53202**

LOWER LEVEL ELECTRICAL PLAN

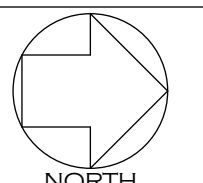

E1.1

© COPYRIGHT 2016 DEEP RIVER PARTNERS, LTD. ALL RIGHTS RESERVED. THIS DOCUMENT, IDEAS AND DESIGN INCORPORATED HEREIN ARE THE PROPERTY OF DEEP RIVER PARTNERS, LTD. AND ARE NOT TO BE USED WHOLE OR IN PART WITHOUT THE WRITTEN CONSENT OF DEEP RIVER PARTNERS, LTD.