


WEST SHORE PIPELINE COMPANY

124TH STREET RELOCATE - 16" PETROLEUM PIPELINE

ALIGNMENT DRAWINGS

AUGUST 2004

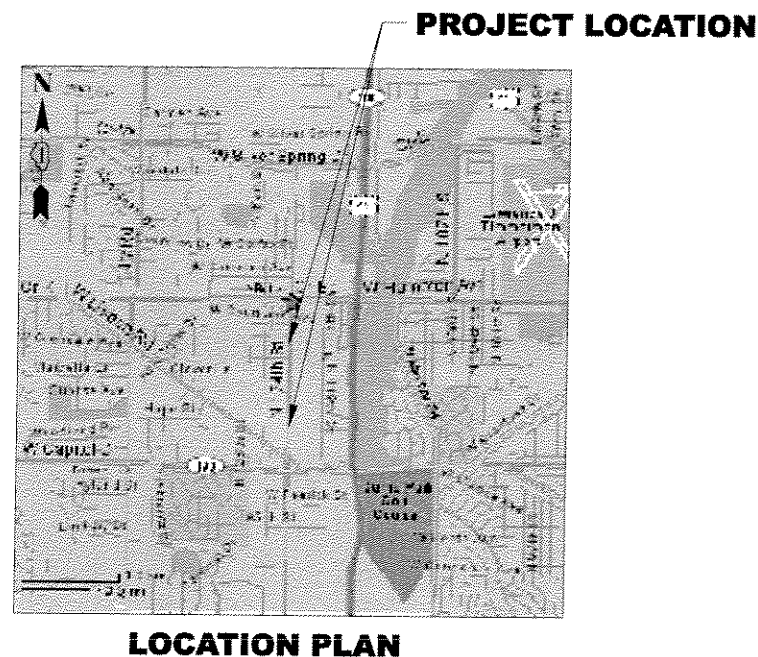




<u>SHEET</u> <u>No.</u>	<u>TITLE</u>	<u>DESCRIPTION</u>
1	COVER	SHEET INDEX AND LOCATION MAP
2	CP-1	PLAN AND PROFILE STA 24+00 TO STA 30+00
3	CP-2	PLAN AND PROFILE STA 30+00 TO STA 36+00
4	CP-3	PLAN AND PROFILE STA 36+00 TO STA 41+00
5	CP-4	PLAN AND PROFILE STA 41+00 TO STA 47+00
6	CP-5	PLAN AND PROFILE STA 47+00 TO END STA

GENERAL NOTES



- 1.) PIPE TO BE WELDED IN ACCORDANCE W/
- 2.) ALL BENDS SHALL BE 5D RADIUS HEAT INDUCED PIPE BENDS
PER OWNER SPECIFICATION
- 3.) PIPE SHALL BE INSTALLED WITH A MINIMUM 4 FEET COVER
- 4.) MAINTAIN A MINIMUM OF 12 INCHES CLEARANCE BETWEEN PIPE
AND FOREIGN LINE CROSSINGS
- 5.) ABANDONED PIPE SECTION TO BE LEFT IN PLACE AND FILLED W/GROUT

CAMP DRESSER & McKEE INC.
MILWAUKEE, WISCONSIN

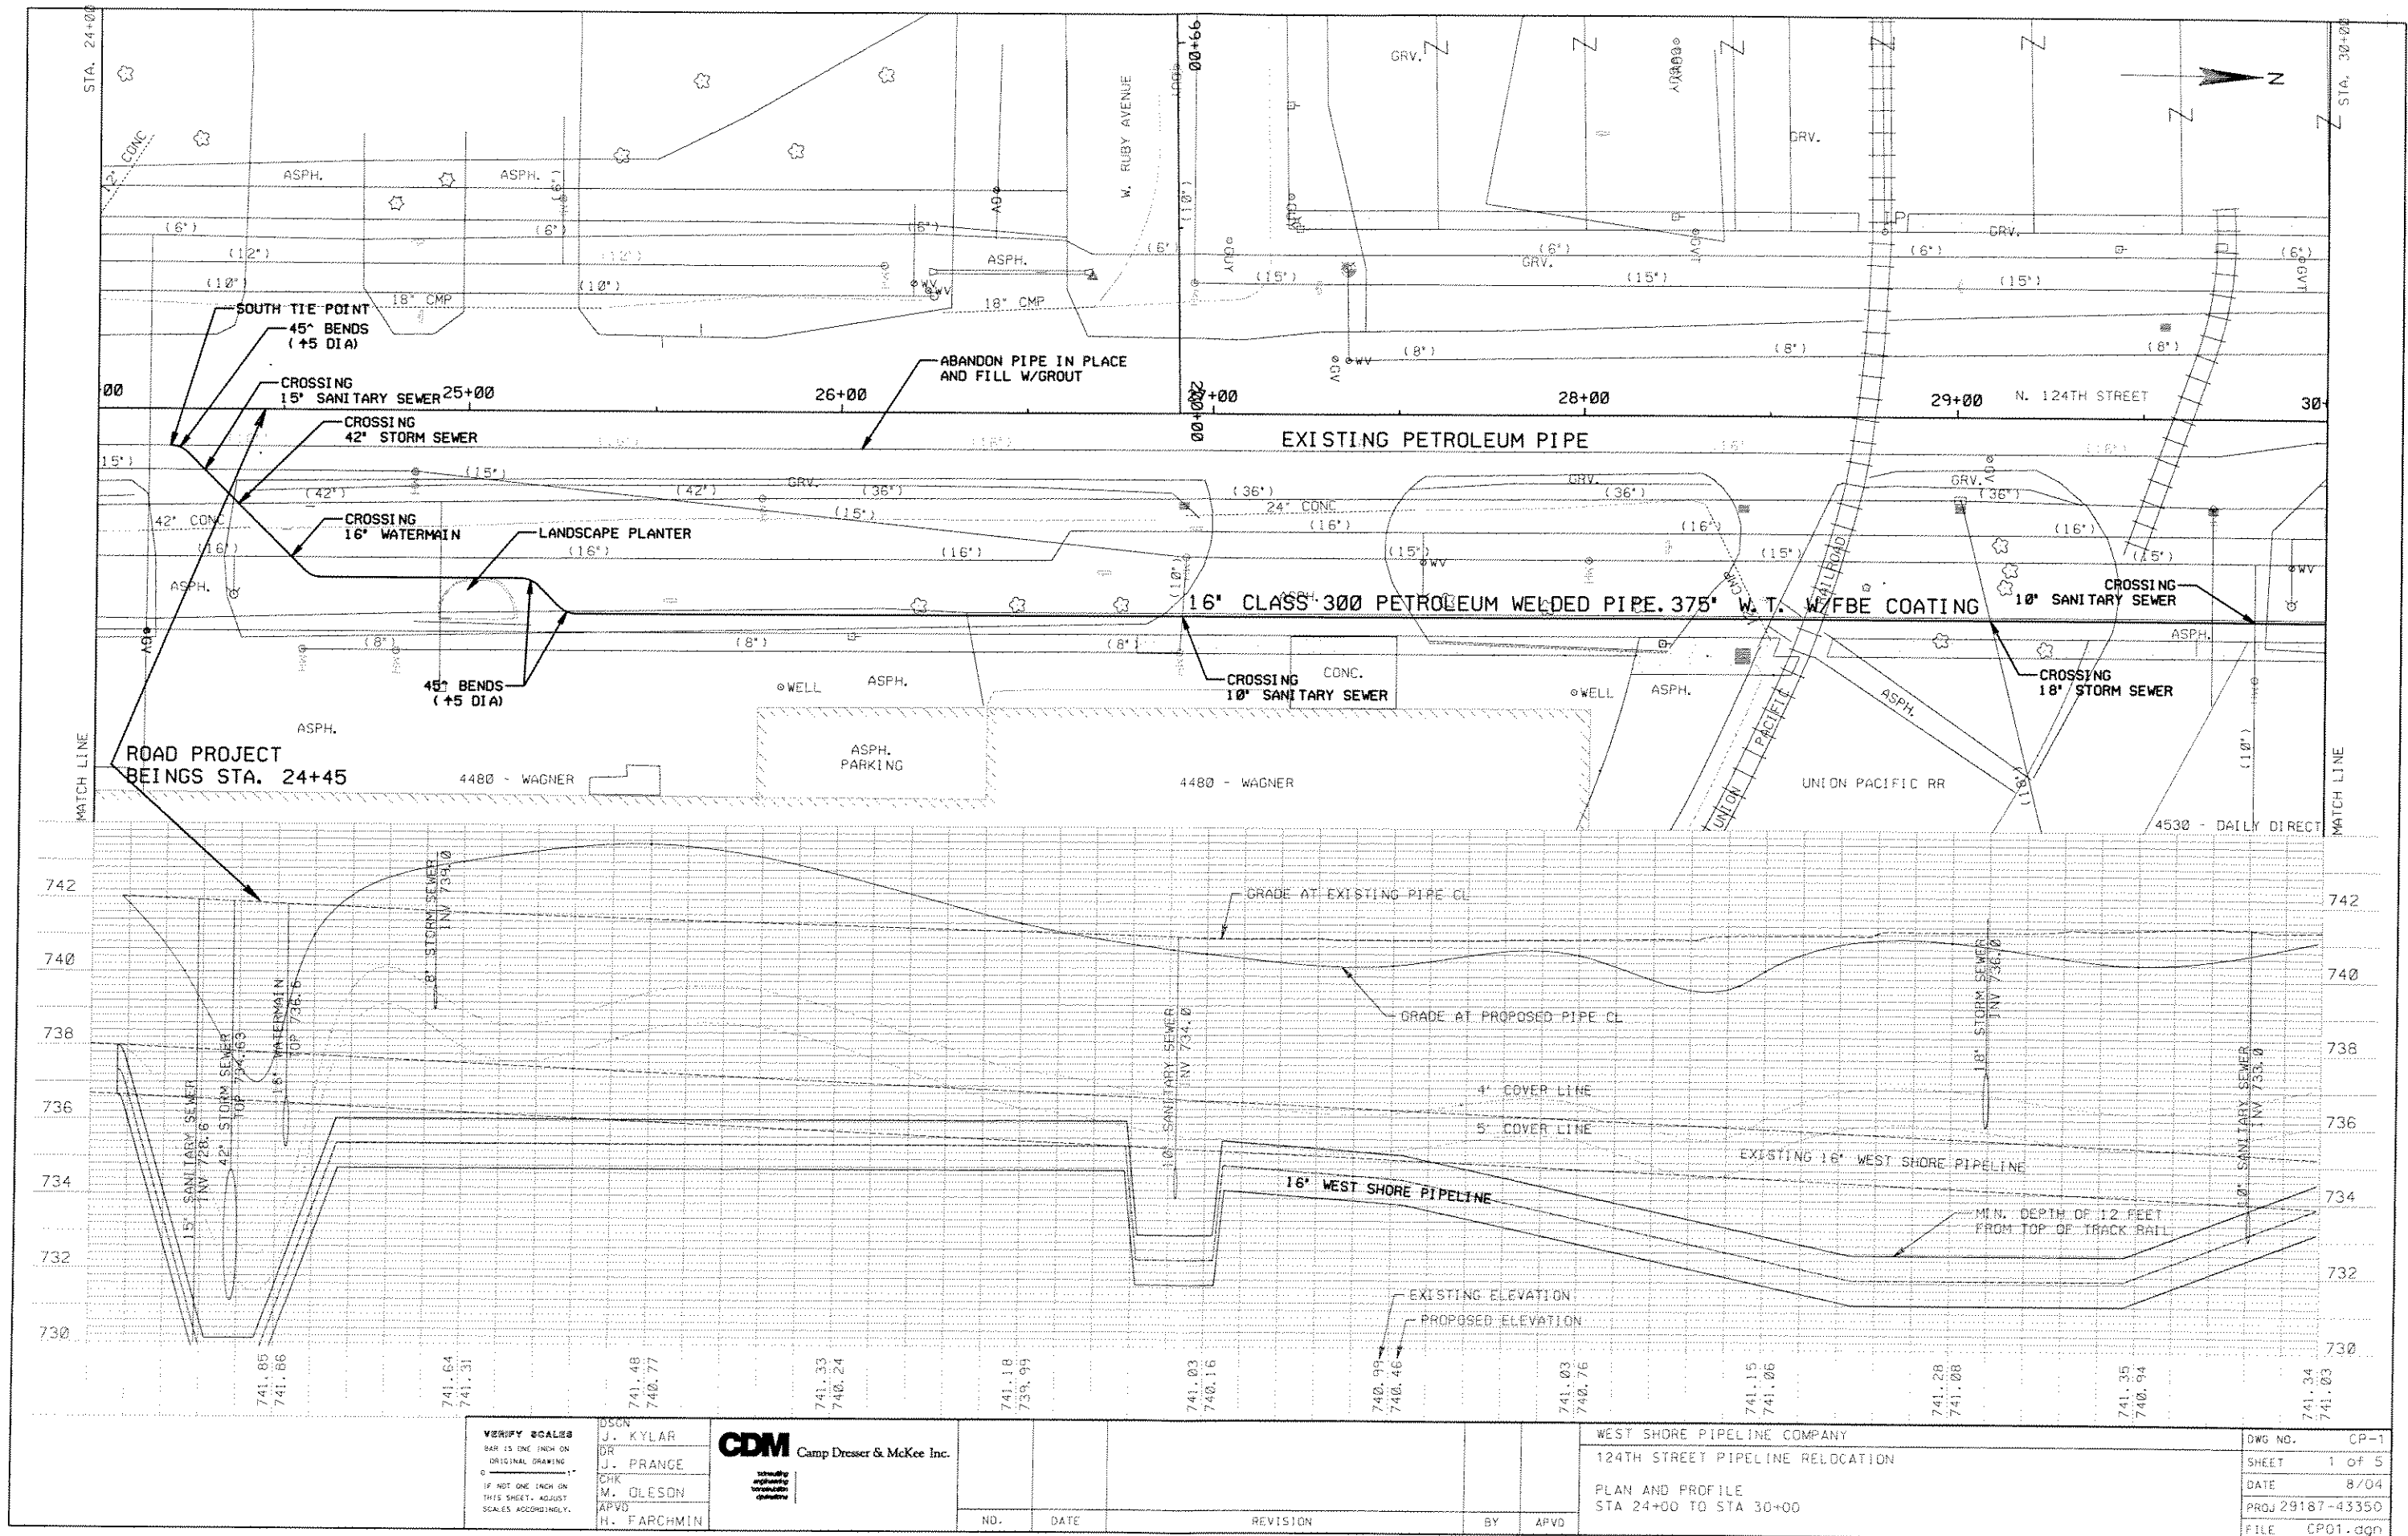

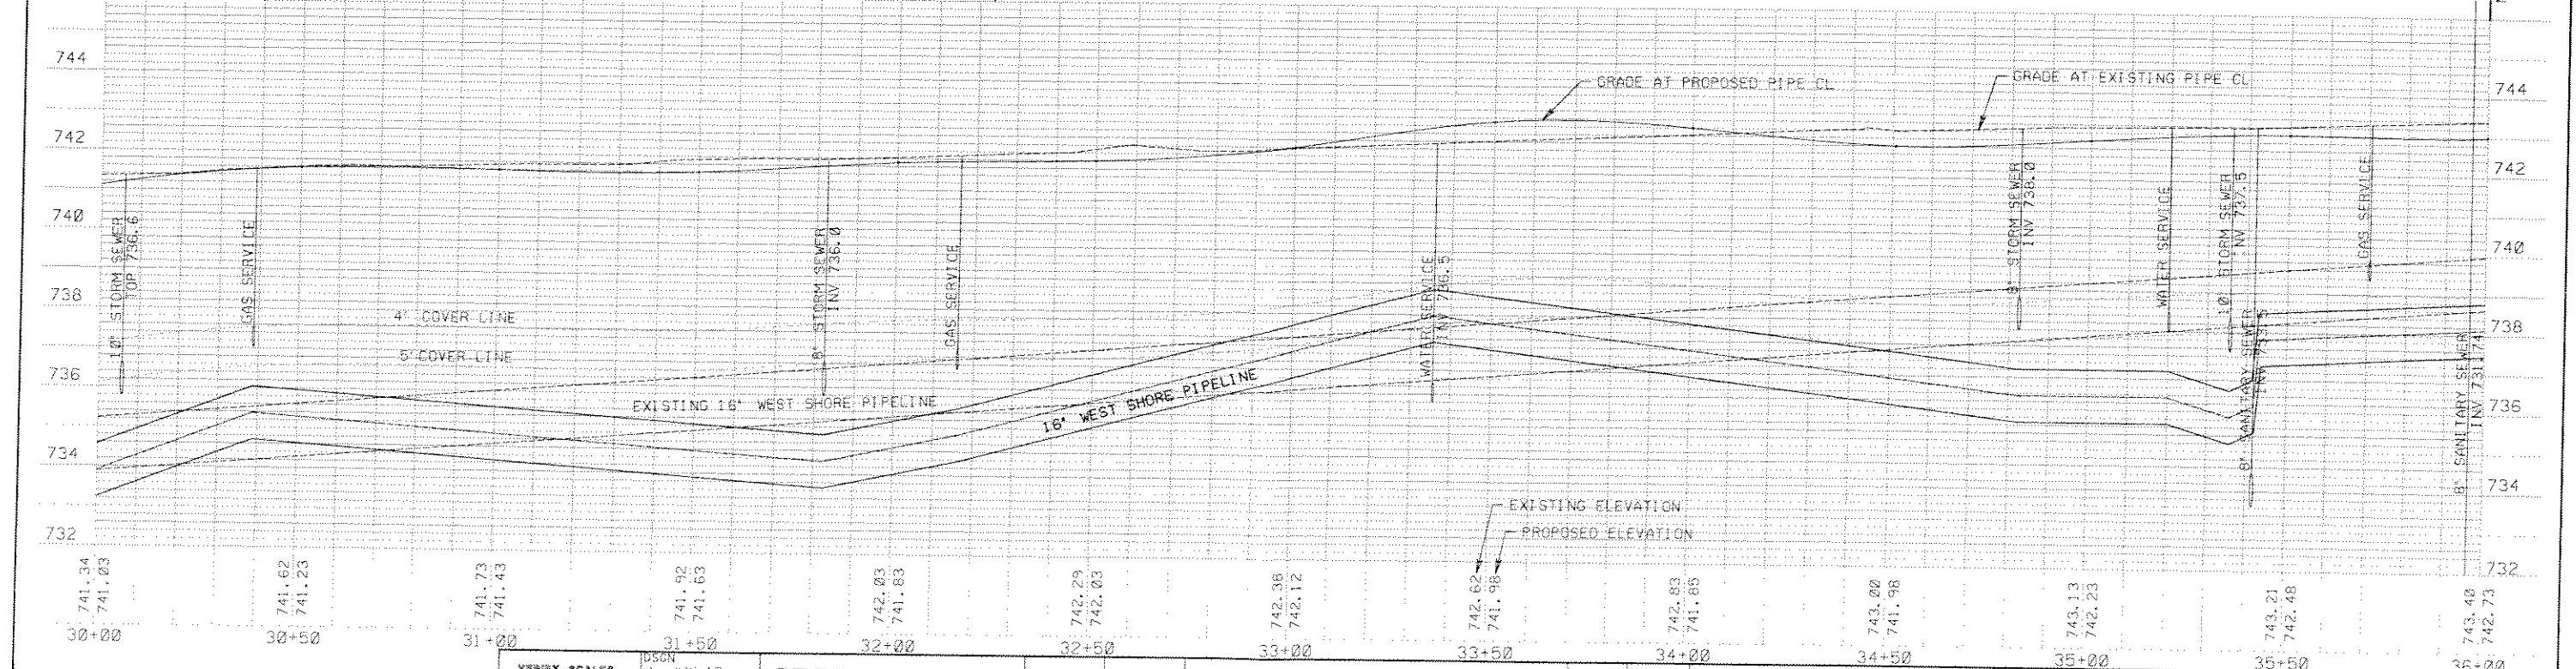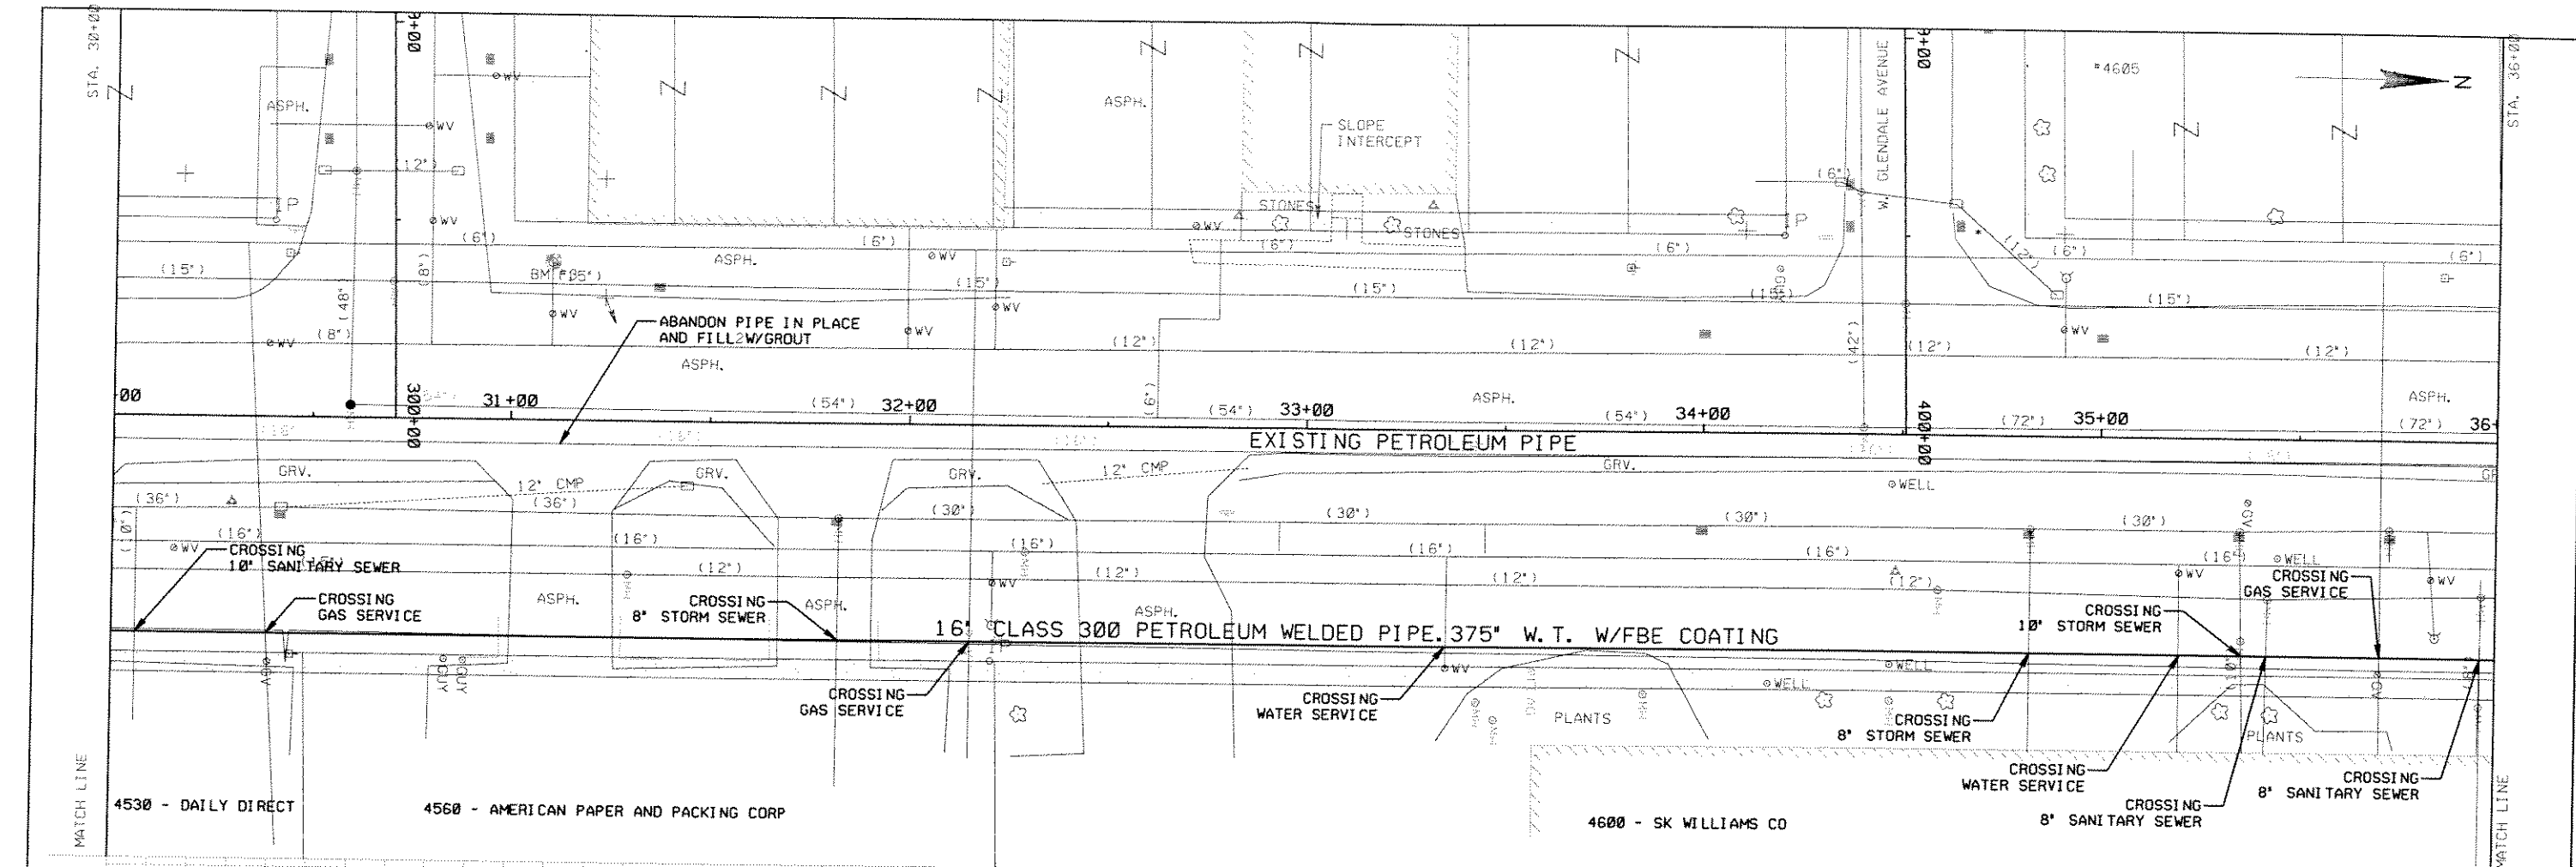

VERIFY SCALES BAR IS ONE INCH ON ORIGINAL DRAWING IF NOT ONE INCH ON THIS SHEET, ADJUST SCALES ACCORDINGLY.	DESIGN	30+00	33+00	33+50	34+00	34+50	35+00	35+50	36+00	
	J. KYLAR	 CDM Camp Dresser & McKee Inc. consulting engineering environmental science				WEST SHORE PIPELINE COMPANY			DWC NO.	CP-2
	J. PRANCE					124TH STREET PIPELINE RELOCATION			SHEET	2 of 5
	CHK M. OLESON					PLAN AND PROFILE			DATE	8/04
	APVD H. FARCHMIN					STA 30+00 TO STA 36+00			PROJ	29187-43350
	NO.	DATE	REVISION	BY	APVD				FILE	CP02.dgn

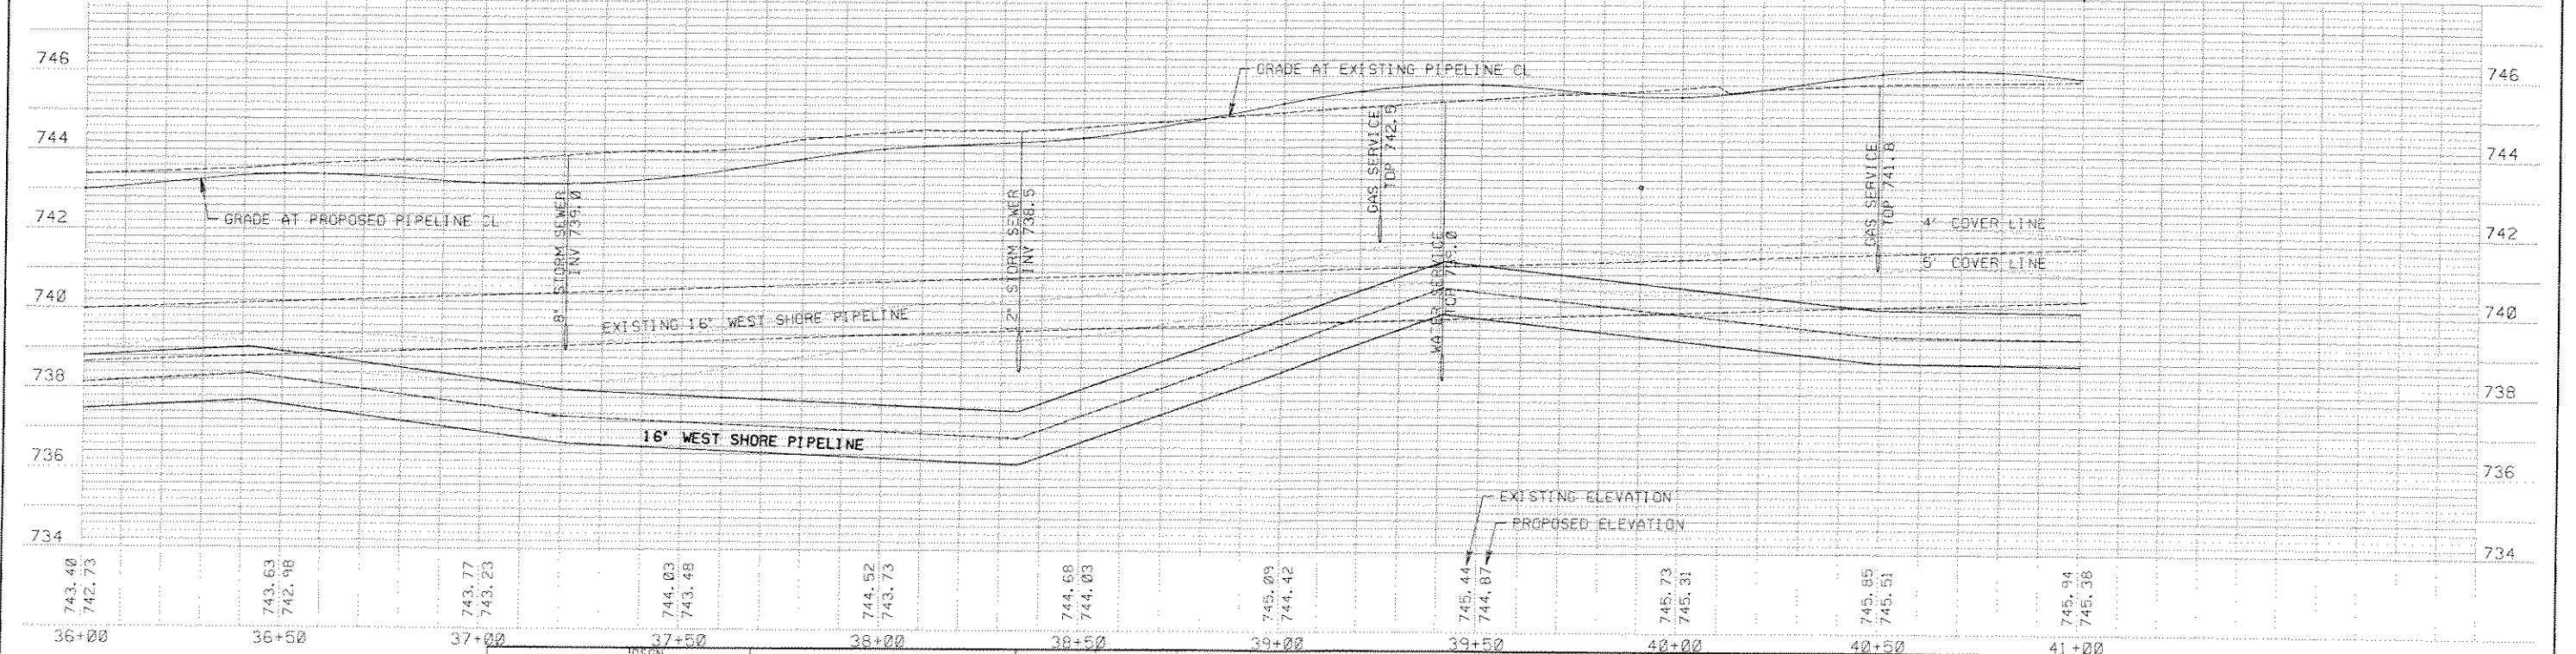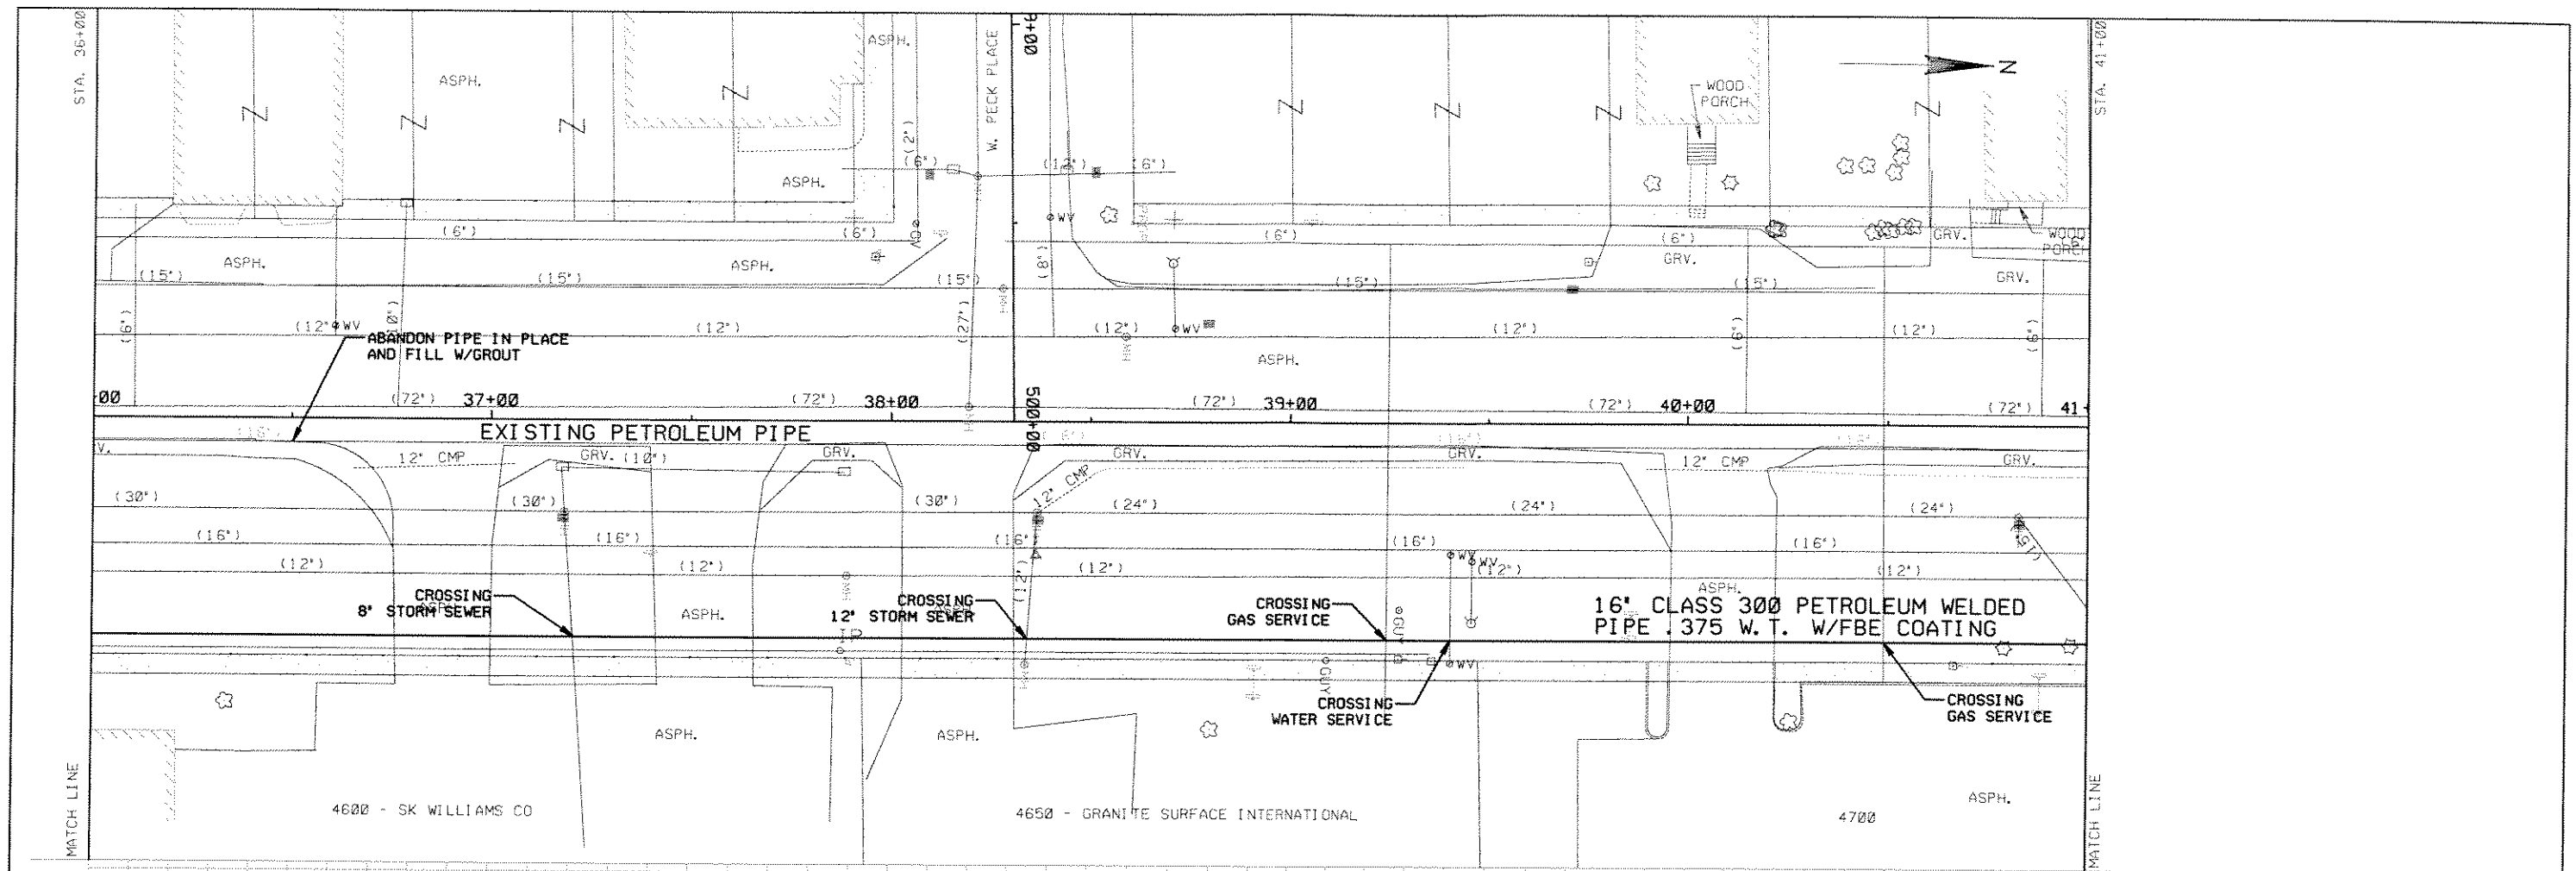

VERIFY SCALAR
BAR IS ONE INCH ON
ORIGINAL DRAWING
IF NOT ONE INCH ON
THIS SHEET, ADJUST
SCALES ACCORDINGLY.

DESIGN
J. KYLAR
OR
J. PRANGE
CHK
M. OLESN
APVD
H. FARCHMIN

CDM Camp Dresser & McKee Inc.

NO.	DATE	REVISION	BY	APVD

WEST SHORE PIPELINE COMPANY
124TH STREET PIPELINE RELOCATION
PLAN AND PROFILE
STA 36+00 TO STA 41+00

DWG NO. CP-3
SHEET 3 of 5
DATE 8/04
PROJ 29187-43350
FILE CP03.dgn

