


W:\PROJECT\368\2015 lighting\368-1.dwg, 12/16/2015 1:16:53 PM

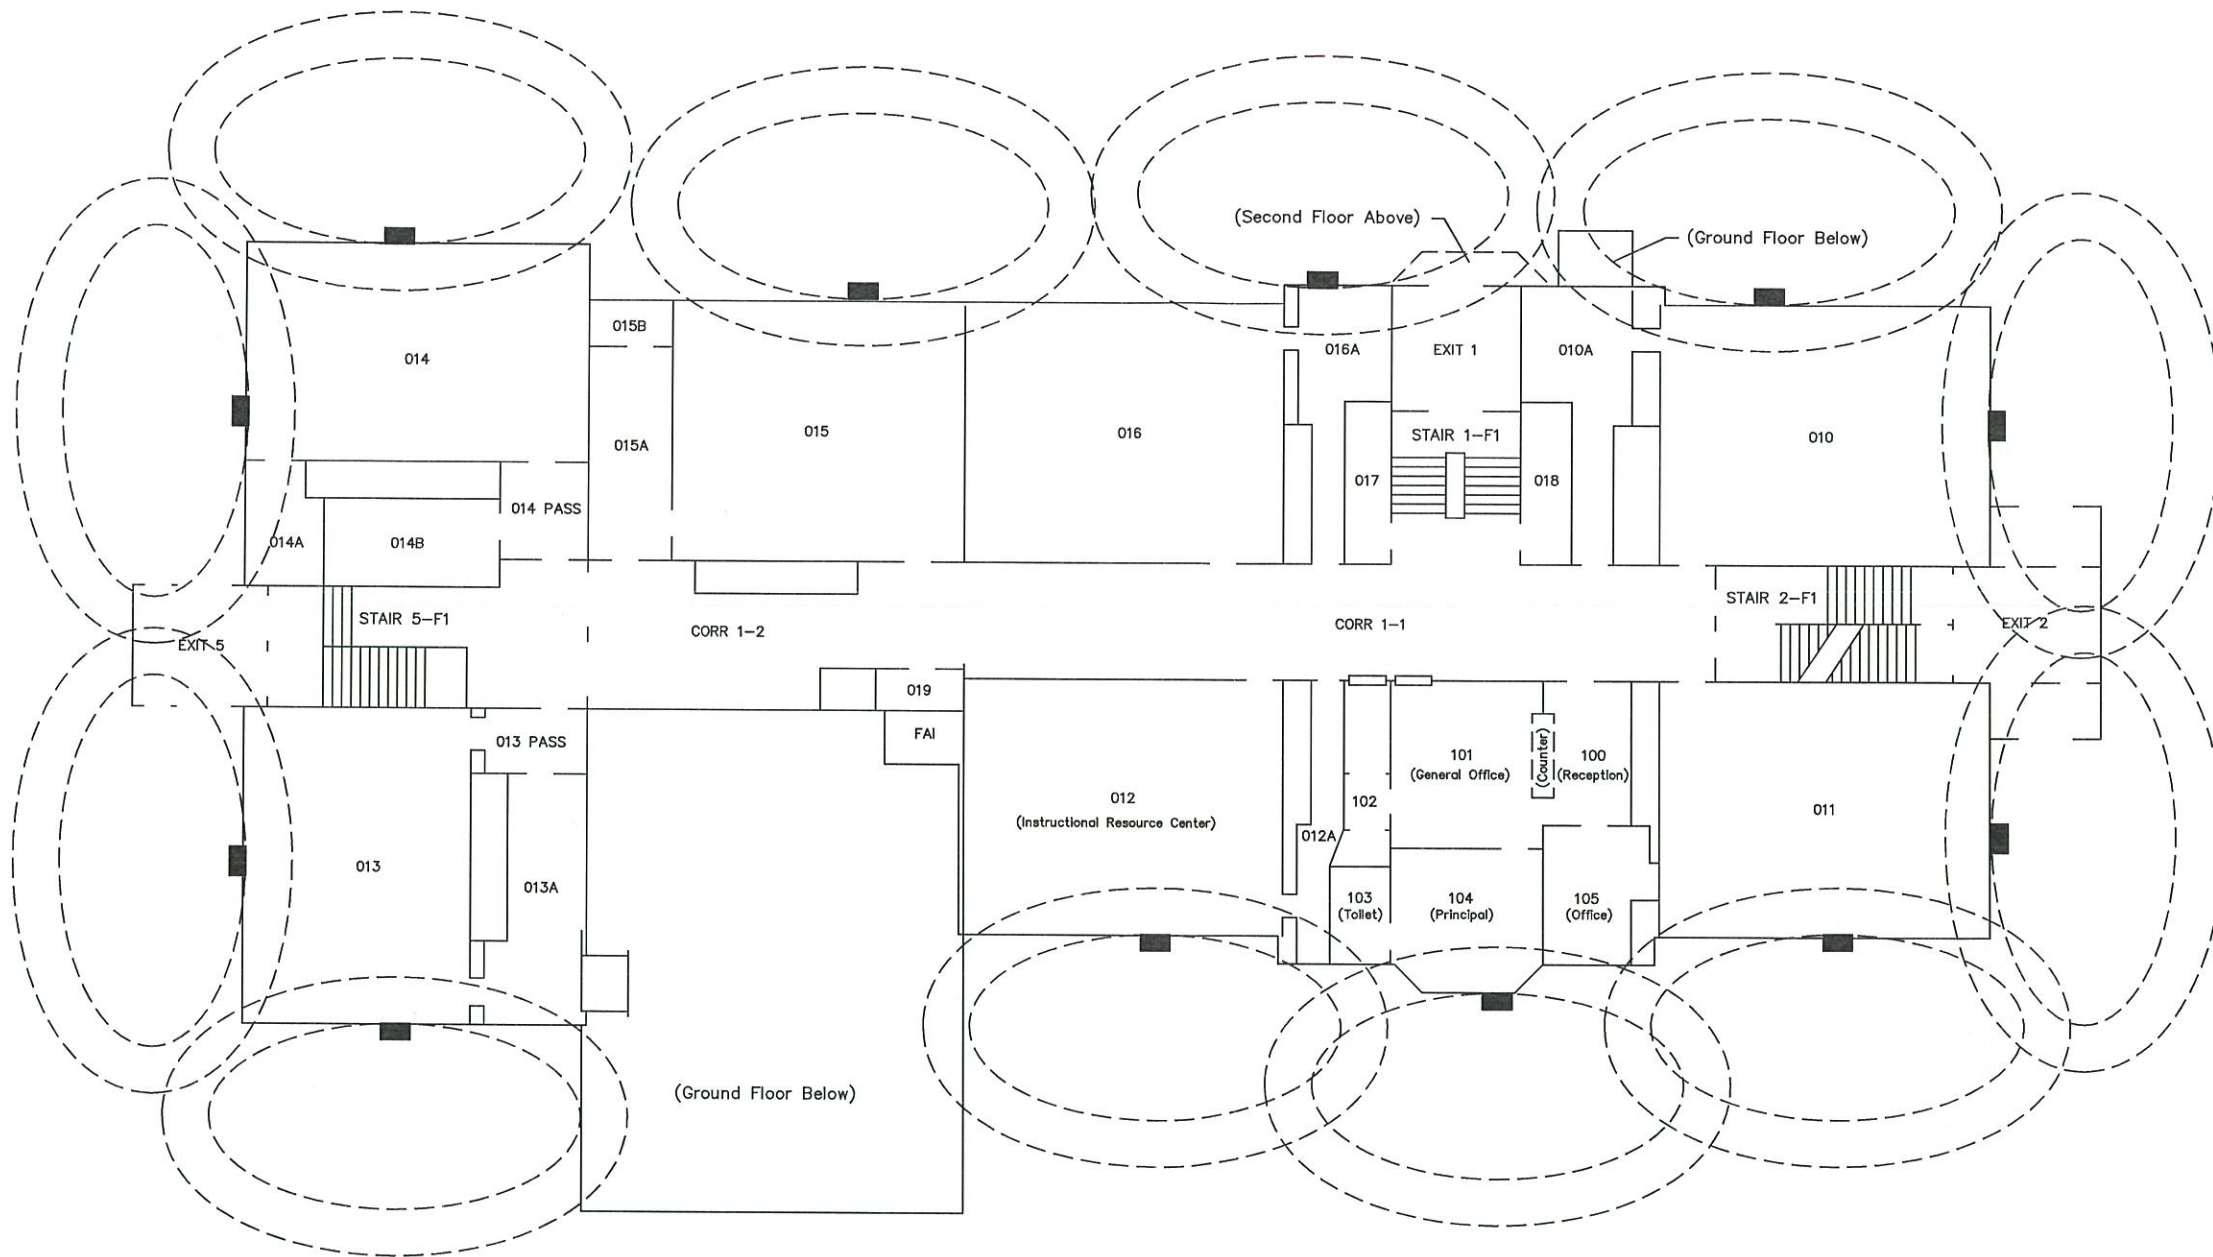

FIRST FLOOR PLAN WITH OUTSIDE LIGHTING

SCALE: 1"=20'-0"



SITE NO. 368 - TROWBRIDGE - FY15 LIGHTING

Title : FIRST FLOOR LIGHTING PLAN W/OUTSIDE LIGHTING

Project Title : 2016 LIGHTING UPGRADE

Project Location : 368 TROWBRIDGE 1943 E TROWBRIDGE ST.

Approved By : JOHN LINN

REVISIONS	BY
12-16-15 HPC	JWG

Drawn by :	J.Gorecki
Checked by :	J.Gorecki
Date :	12-16-15
Scale :	As Noted
Site Number :	368
Project No.:	3699
Sheet Number :	

E1

SHEET 1 OF 1

Office of Operations
Department of Facilities
Travis Luzney - Director
1124 N. 11th Street, Milwaukee, WI 53233
(414) 283-4600 mps.milwaukee.k12.wi.us



MILWAUKEE
PUBLIC SCHOOLS